

REVISIONS	BY
06-21-10	ADG
07-12-10	ADG



GENERAL NOTES:

1) ADDITIONAL FIRE ALARM DEVICES MAY BE REQUIRED BY APPLICABLE BUILDING CODES AND/OR THE STATE FIRE MARSHALL. IT IS THE CONTRACTOR'S RESPONSIBILITY TO INSURE THAT ALL FIRE ALARM DEVICES ARE INCLUDED IN THE BID AND TO CONFIRM THAT THE BUILDING'S FIRE ALARM SYSTEM MEETS ALL APPLICABLE CODES AND REQUIREMENTS OF THE STATE FIRE MARSHALL. THE CONTRACTOR SHALL PROVIDE ALL FIRE ALARM CONTRACT DOCUMENTS OR NOT.


CONTRACTOR MUST VERIFY AND CHECK ALL JOB DIMENSIONS, NOTES AND SPECIFICATIONS ON SITE AND REPORT ANY ERRORS, OMISSIONS AND DISCREPANCIES BEFORE PROCEEDING.

NEW PHOENIX PRE-K THROUGH 12 SCHOOL

UNIT B SECOND FLOOR FIRE ALARM PLAN

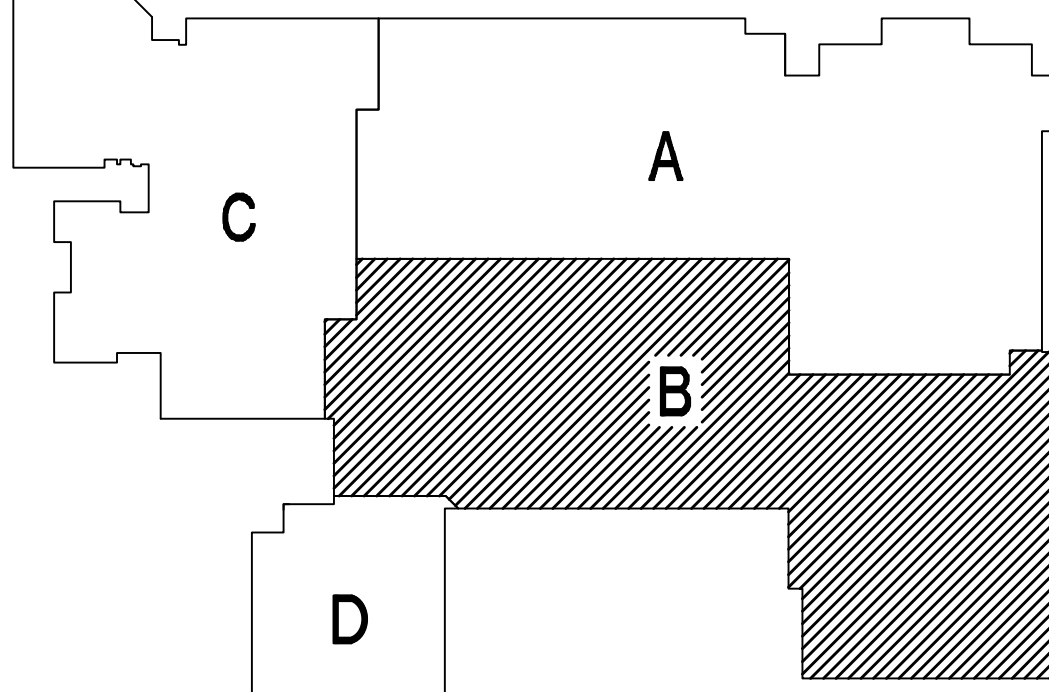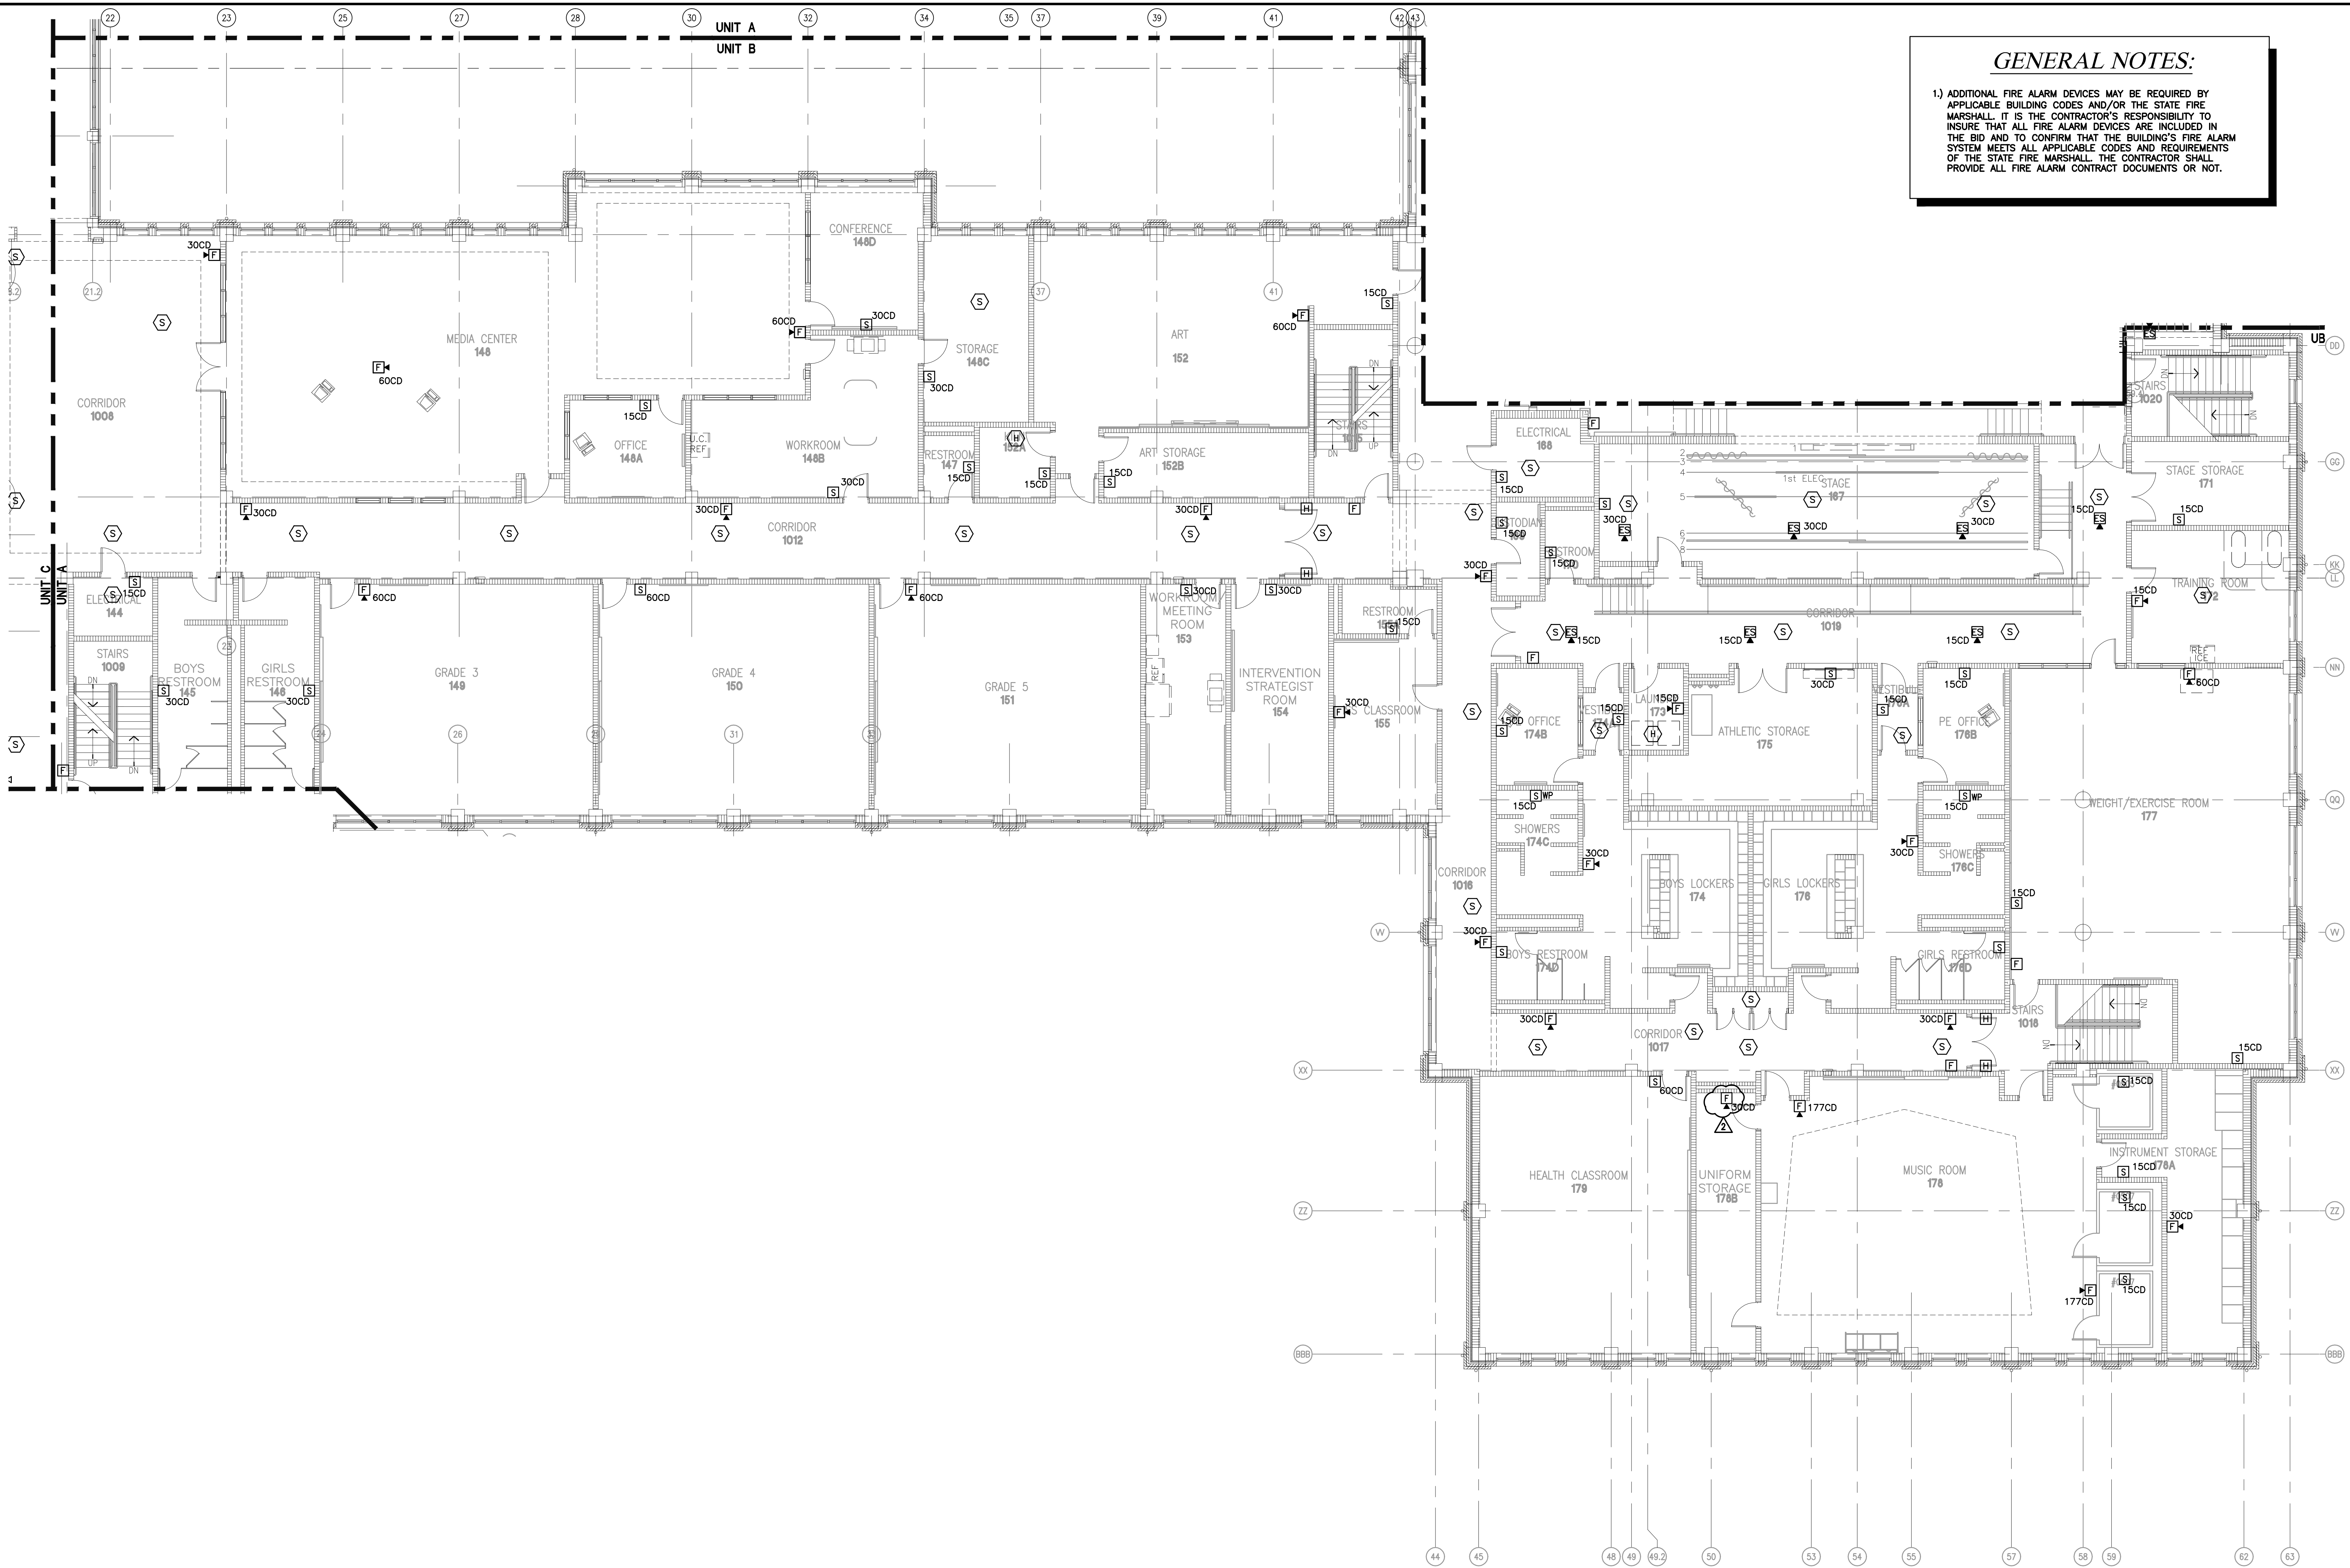

1 UNIT B SECOND FLOOR FIRE ALARM PLAN
SCALE: 1/8" = 1'-0"

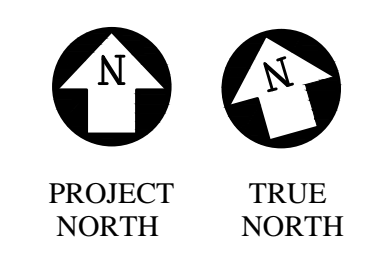

ADDENDUM 2
ATTACHMENT 55

ASSOCIATED DESIGN GROUP, INC.
CONSULTING ENGINEERS

CORPORATE OFFICE
114 Toledo Drive
Lafayette, Louisiana 70506
(337) 284-8710

NEW ORLEANS BRANCH
1010 Common St.
Suite 8405
New Orleans, LA 70112
(504) 561-8333

Project # 02183

DRAWN: JAM
CHECKED: RAG
SCALE:
DATE: 05-24-2010

E2.18