



REVISIONS	BY
07-12-10	ADG

CONTRACTOR MUST VERIFY AND CHECK ALL JOB DIMENSIONS, REVISE AND SPECIFY TO THE SITE AND REPORT ANY ERRORS, OMISSIONS AND DISCREPANCIES BEFORE PROCEEDING.

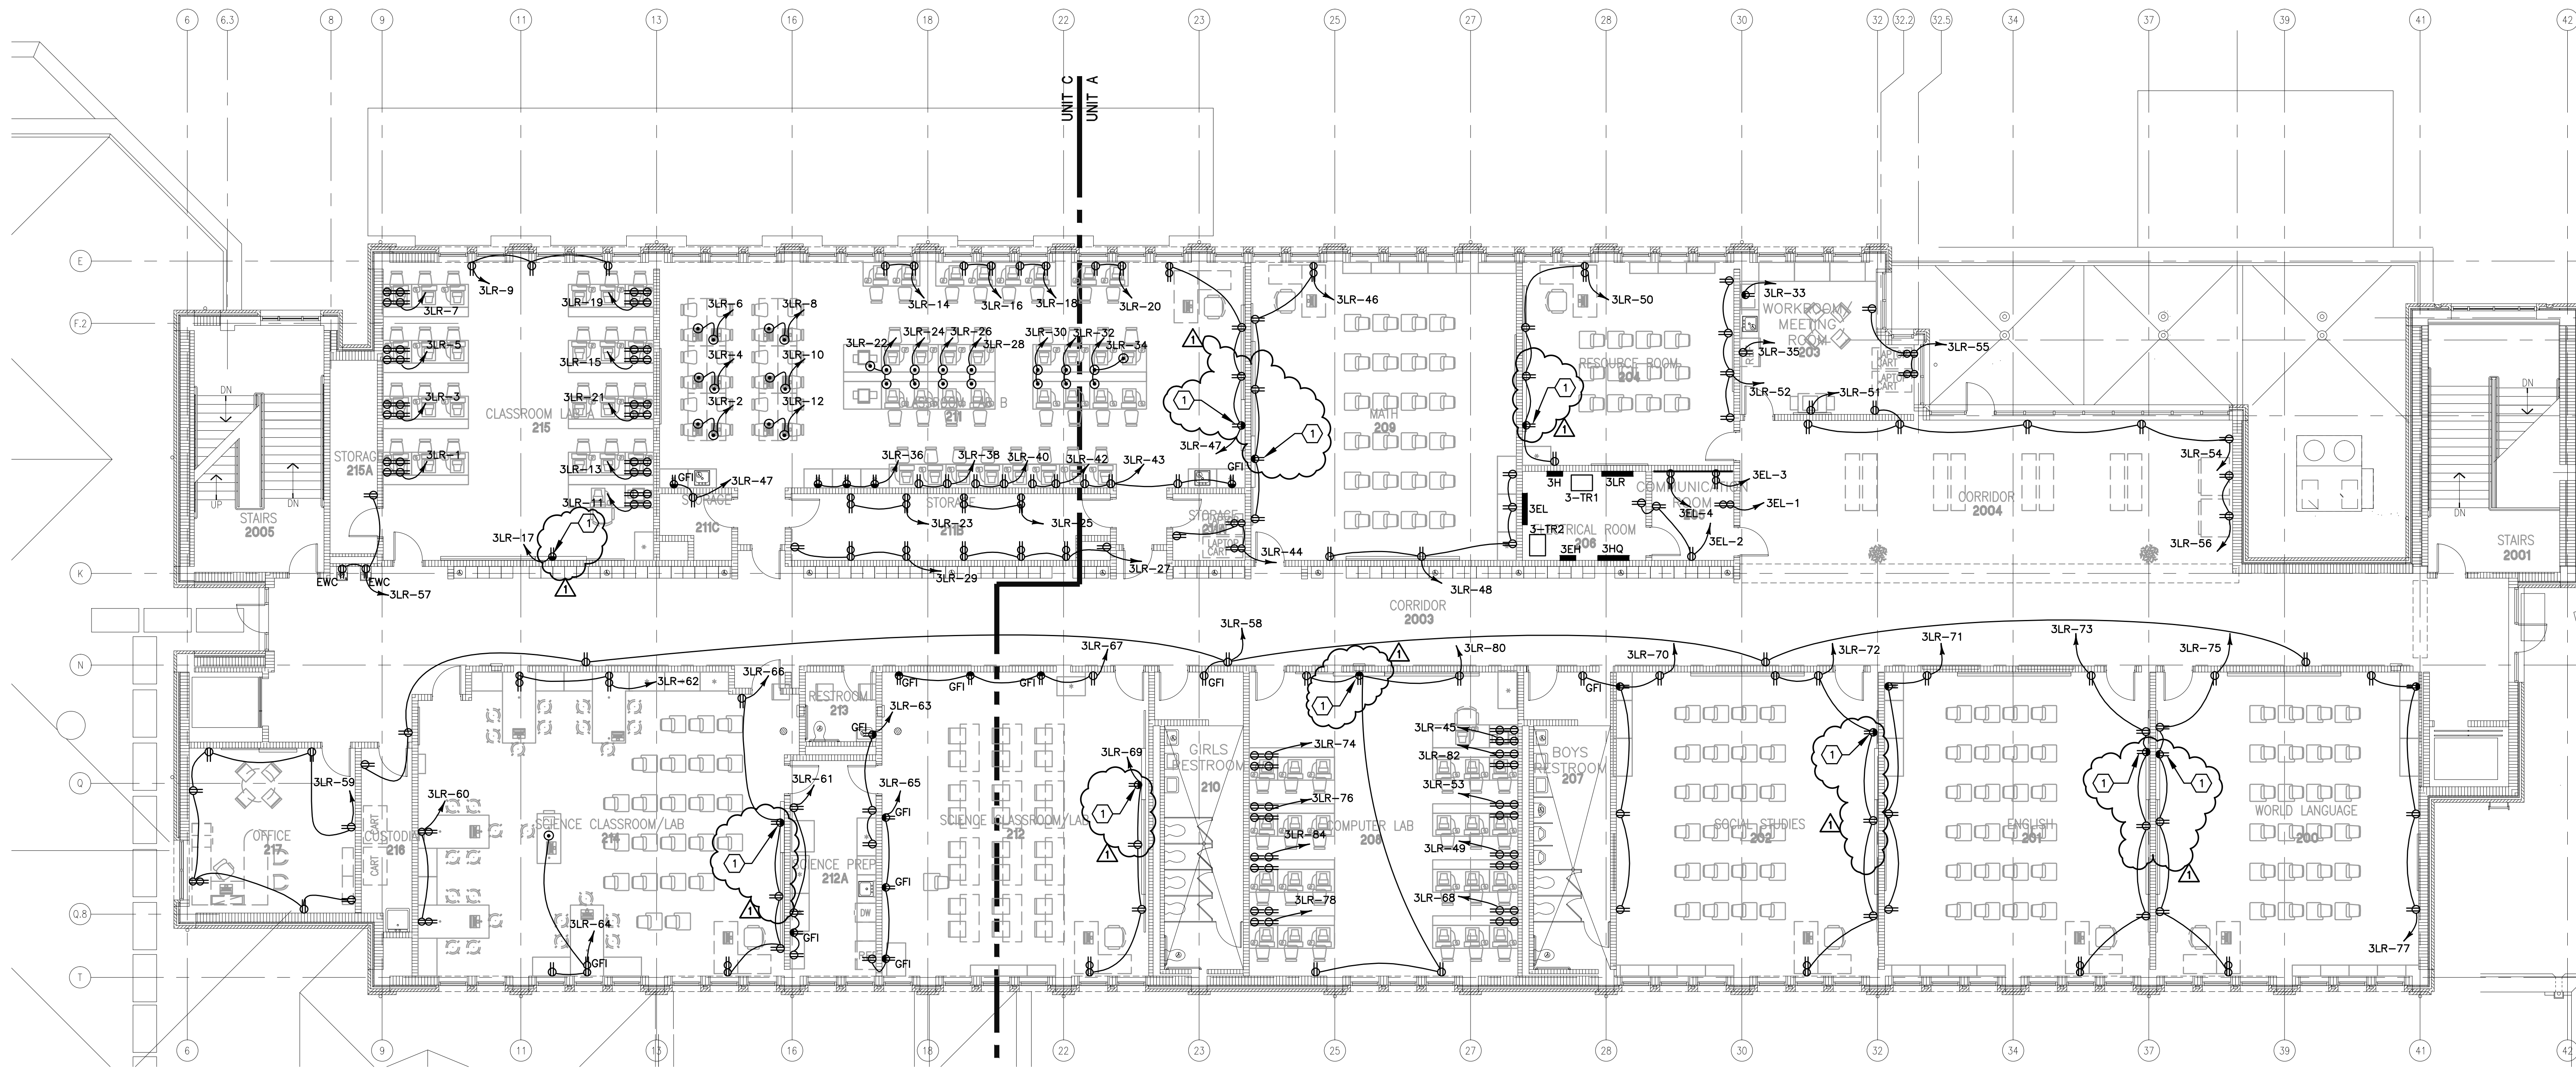


1 UNITS A AND C THIRD FLOOR POWER PLAN
SCALE: 1/8" = 1'-0"

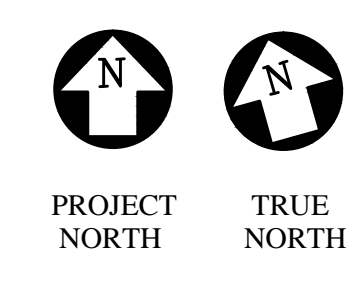

SPECIFIC NOTES:

- 1 MOUNT 12" BELOW FINISHED CEILING FOR SMART BOARD.
- 2 SEE DETAIL 4, SHEET E4.01 FOR ENLARGED ELECTRICAL ROOM PLAN.

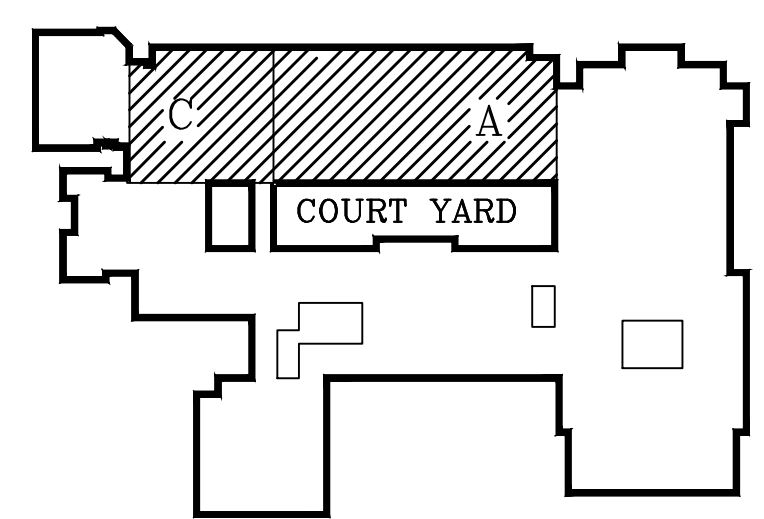

KEY PLAN
NOT TO SCALE

ASSOCIATED DESIGN GROUP, INC.
CONSULTING ENGINEERS

CORPORATE OFFICE
114 Toledo Drive
Lafayette, Louisiana 70508
(337) 234-8710

NEW ORLEANS BRANCH
1010 Common St.
Suite 8405
New Orleans, LA 70112
(504) 561-8333
Project # 02193

UNITS A AND C THIRD FLOOR
POWER PLAN

DRAWN: ABF
CHECKED: RAG
SCALE:
DATE: 05-24-2010

E2.23