


REVISIONS	BY
07-12-10	ADG

CONTRACTOR MUST VERIFY AND CHECK ALL JOB DIMENSIONS, REVISE AND SPECIFYING ON SITE AND REPORT ANY ERRORS, OMISSIONS AND DISCREPANCIES BEFORE PROCEEDING.


NEW PHOENIX PRE-K THROUGH 12 SCHOOL

UNIT B SECOND FLOOR LIGHTING PLAN

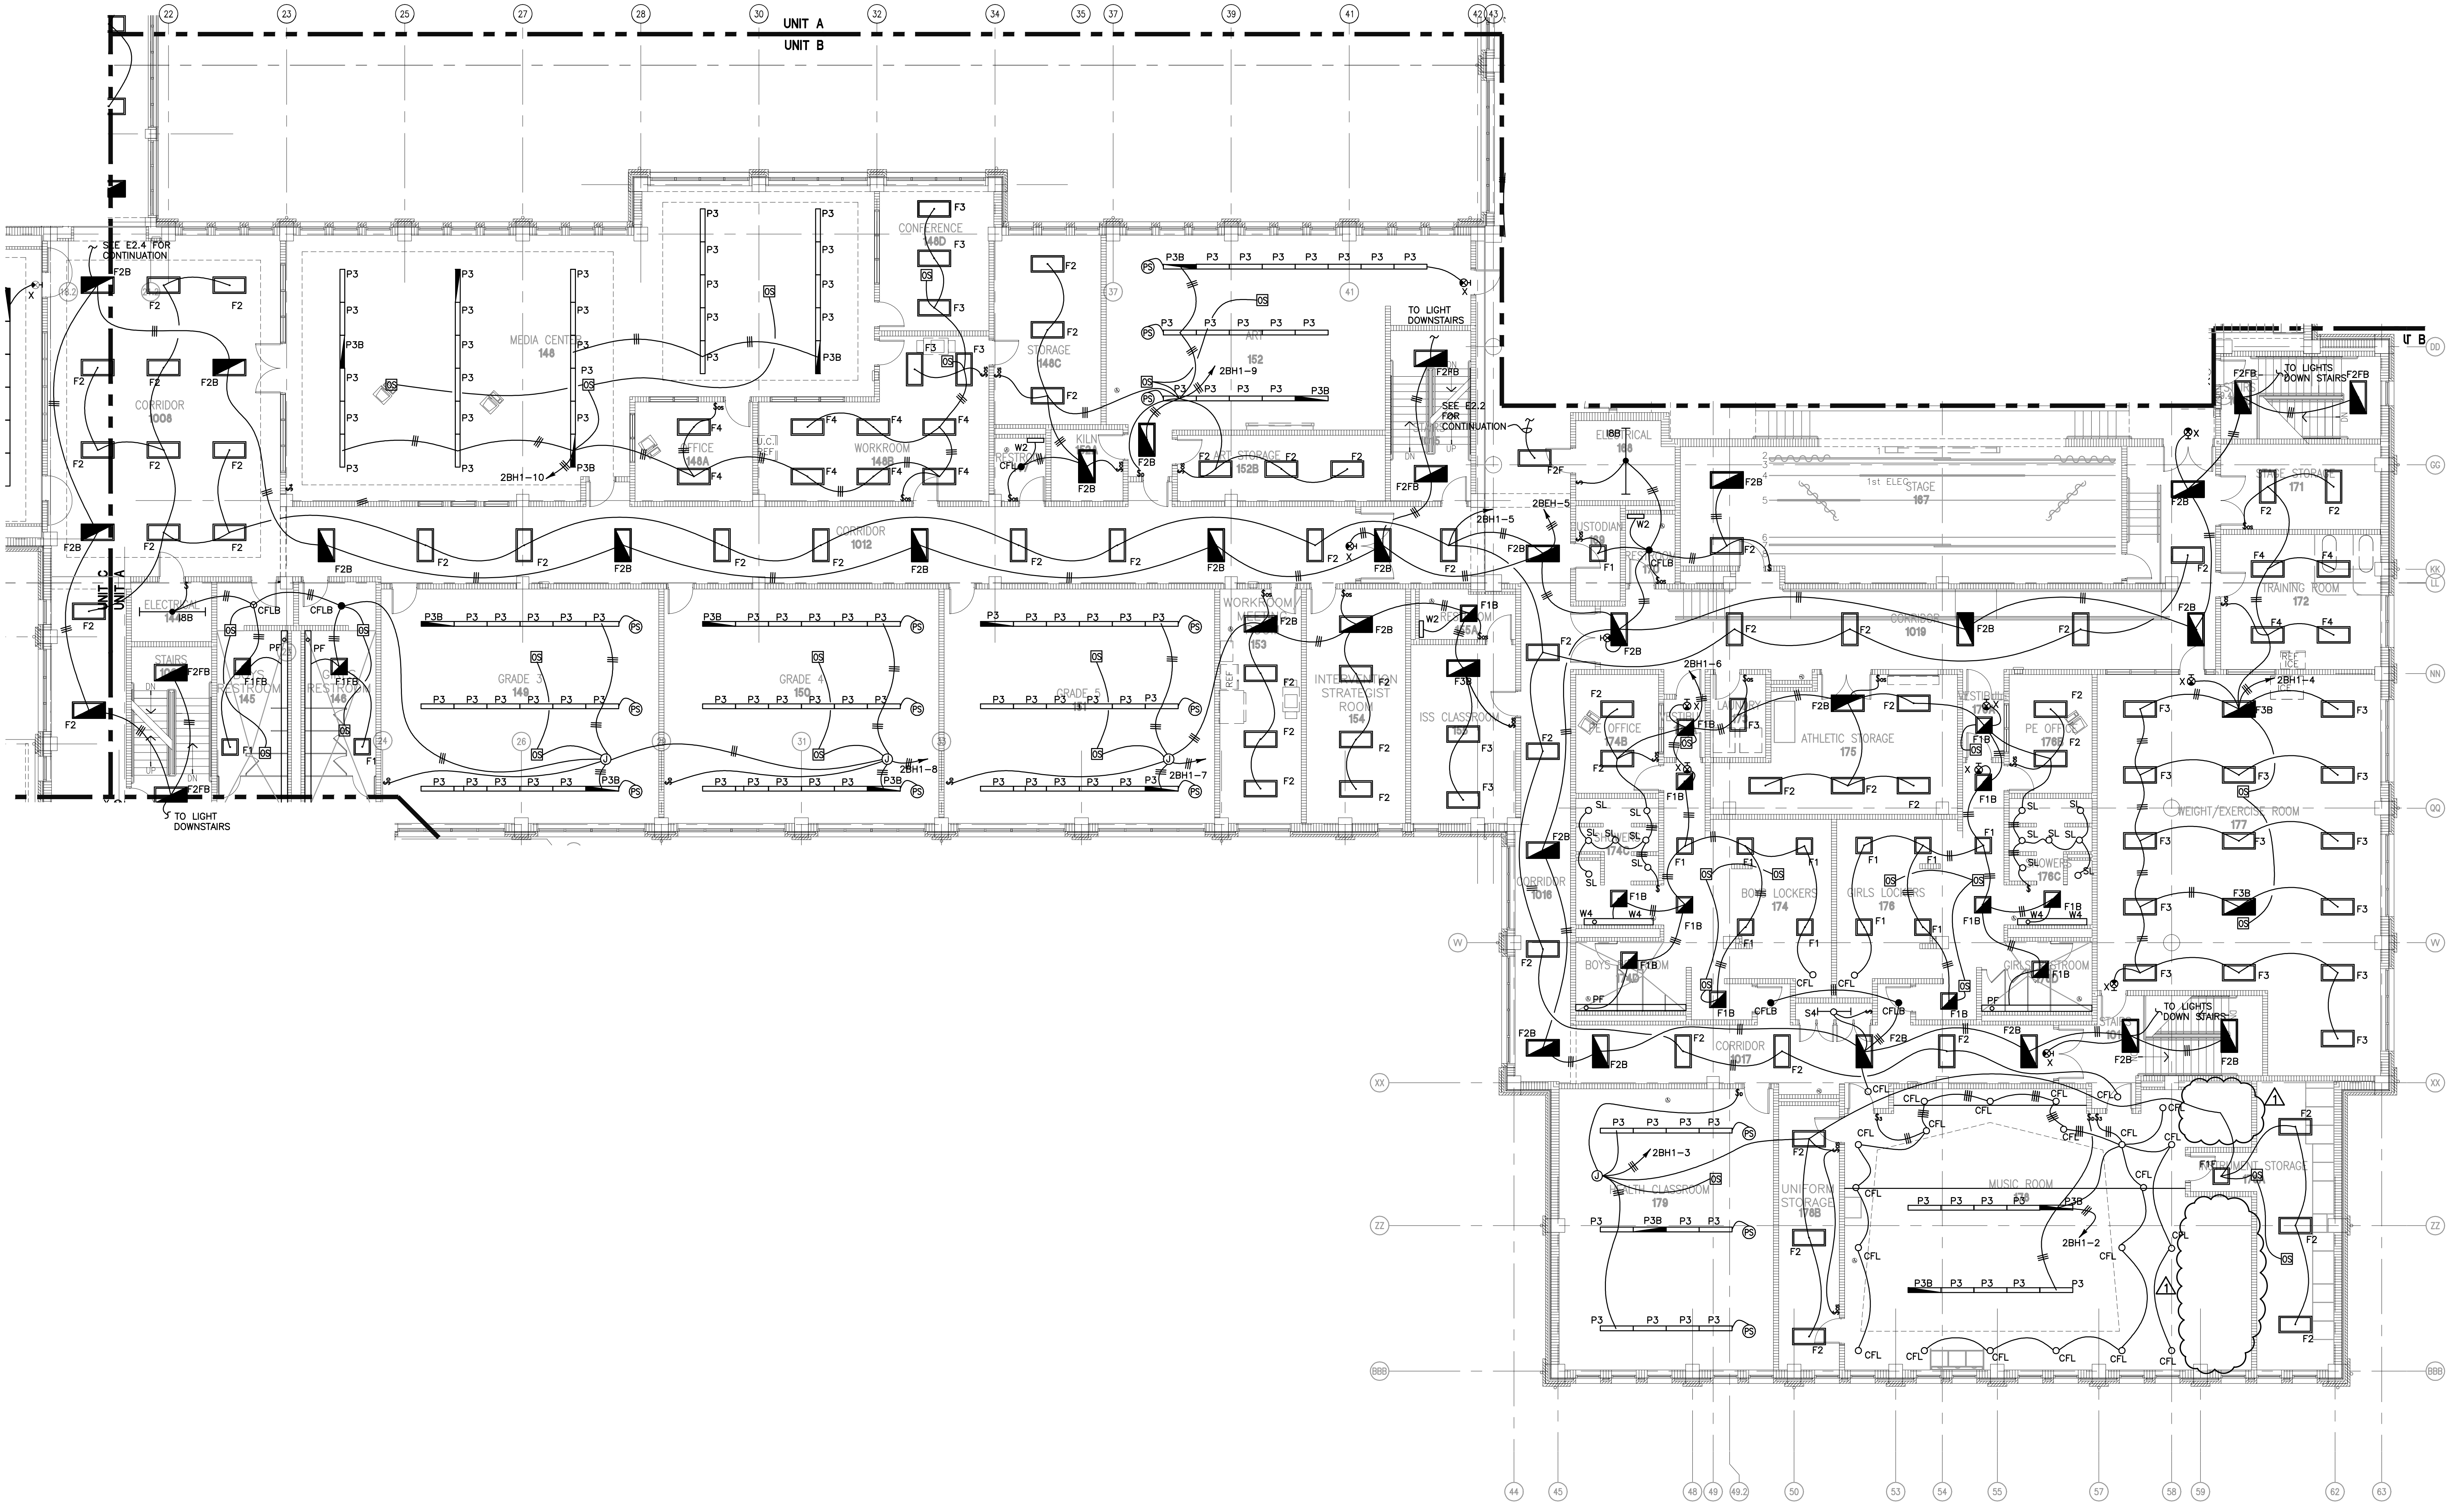


GENERAL NOTES:
 1) CONNECT VOLTAGE SENSING LOAD ON ALL BATTERY BACKED BALLAST TO NON-PROGRAMMABLE SIDE OF TANDEM BREAKER ON CIRCUIT SHOWN.

1 UNIT B SECOND FLOOR LIGHTING PLAN
 SCALE: 1/8" = 1'-0"

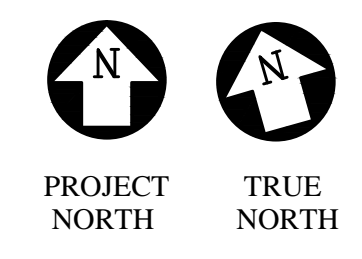

ATTACHMENT 47

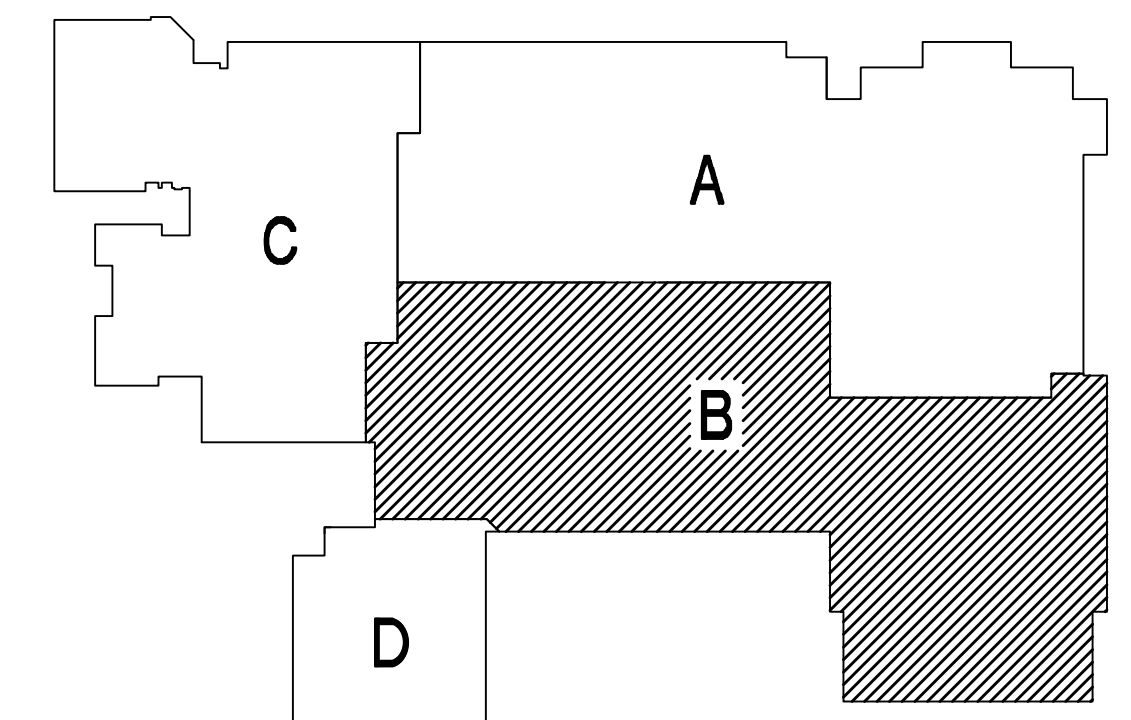

KEY PLAN

ASSOCIATED DESIGN GROUP, INC.
 CONSULTING ENGINEERS

CORPORATE OFFICE
 114 Toledo Drive
 Suite 8405
 New Orleans, Louisiana 70112
 (504) 561-8333

NEW ORLEANS BRANCH
 1010 Common St.
 Suite 8405
 New Orleans, LA 70112
 (504) 561-8333

Project # 02193

DRAWN: JAM, ABF
 CHECKED: RAG
 SCALE:
 DATE: 05-24-2010

E2.3