




REVISIONS	BY
07-12-2010	JSL

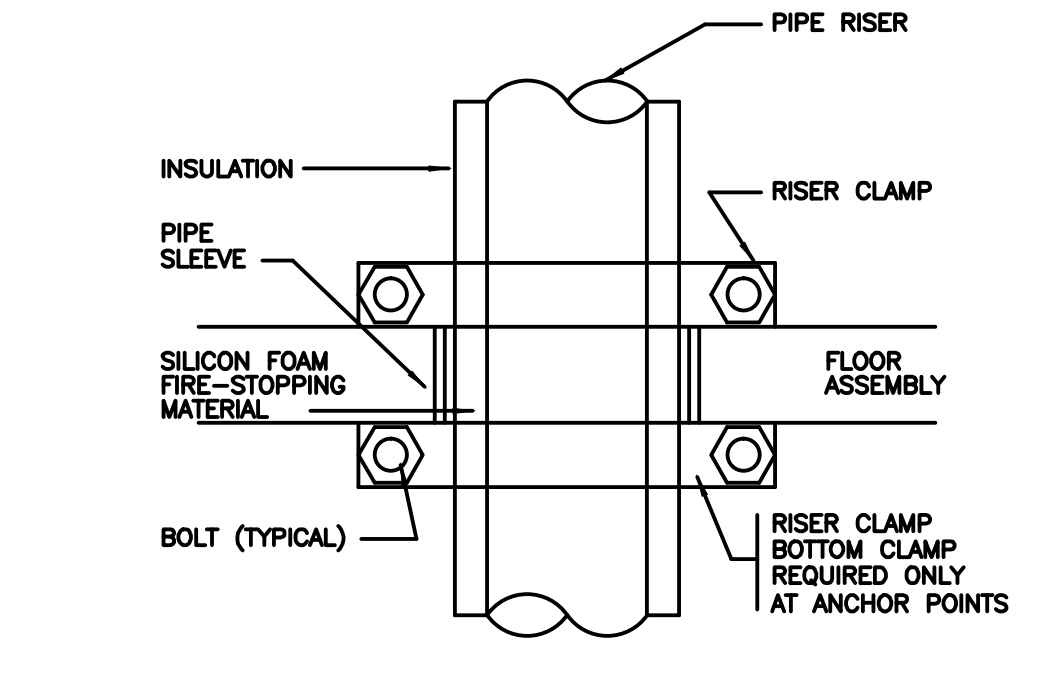


**1 PIPE SUPPORT/ANCHOR THRU FLOOR SLAB**  
M4.3 NO SCALE

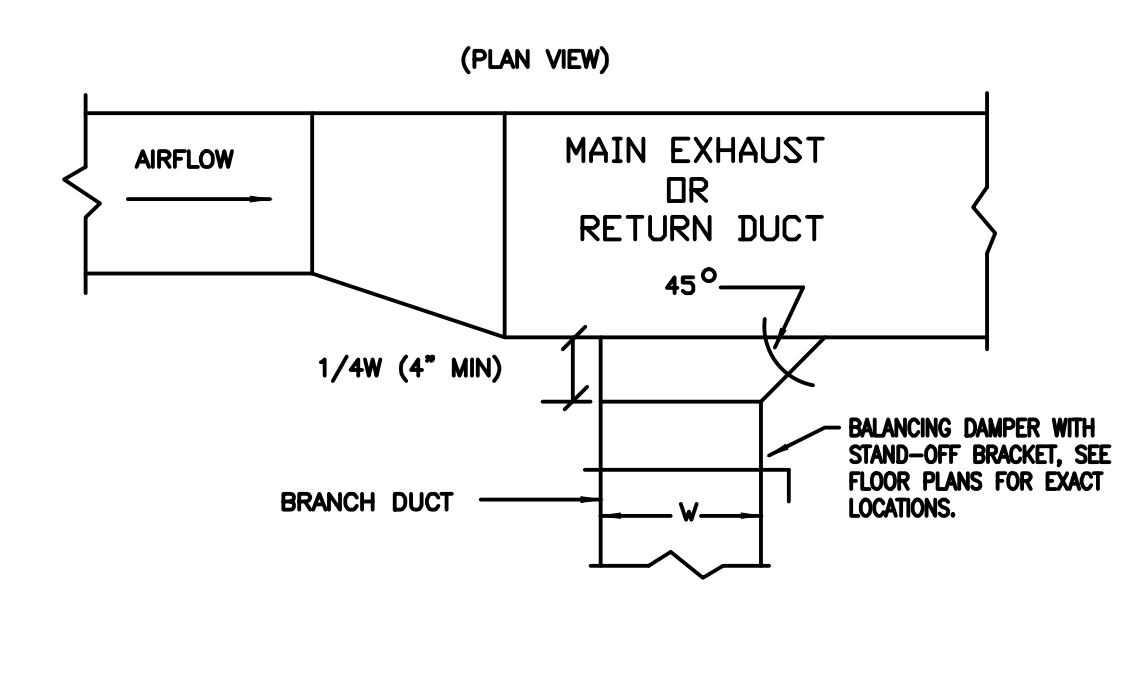


**2 EXHAUST/RETURN BRANCH DUCT DETAIL**  
M4.3 NO SCALE

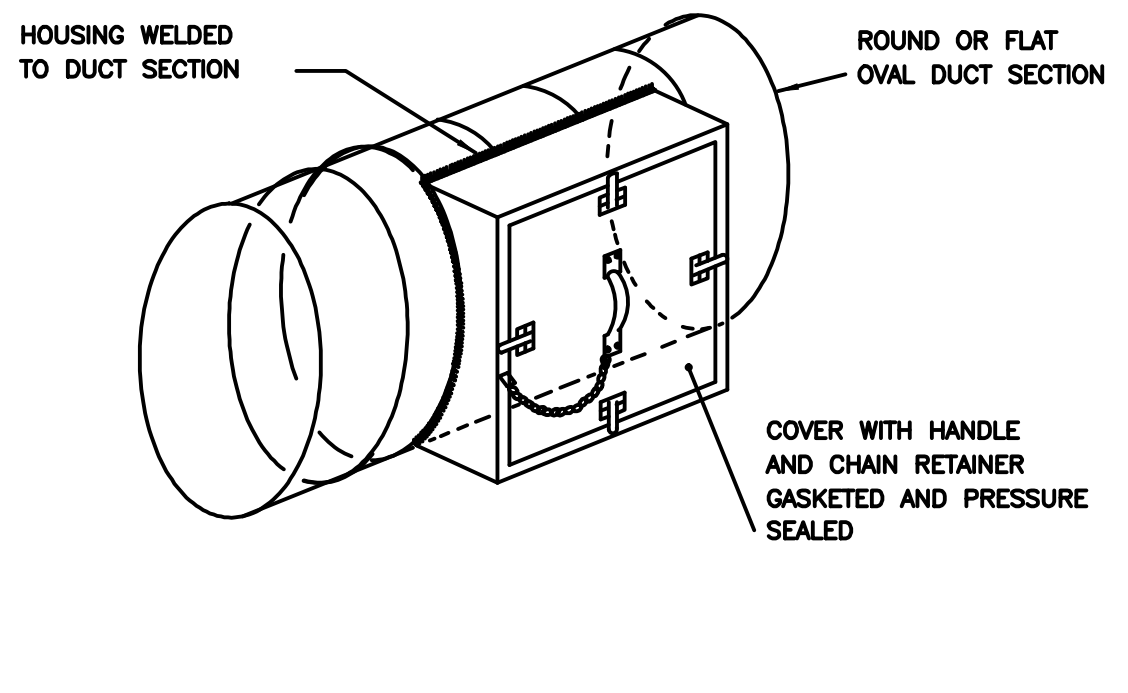


**3 ACCESS PANEL FOR OVAL/ROUND DUCT**  
M4.3 NO SCALE

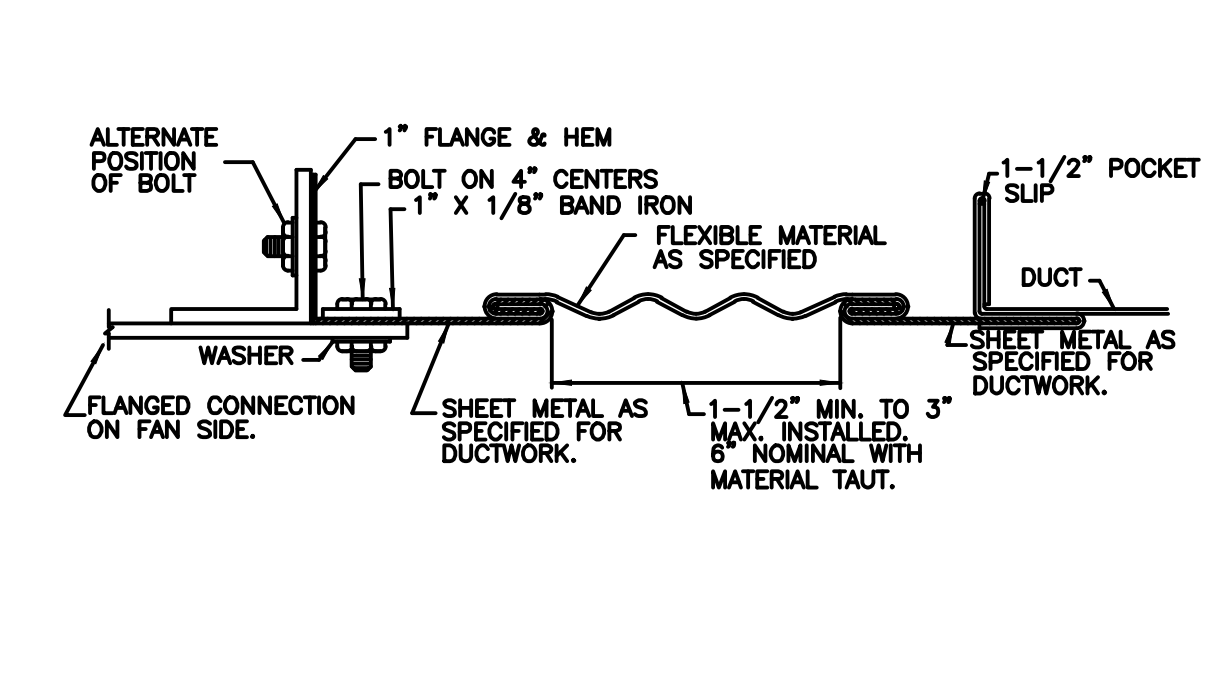


**4 RECTANGULAR DUCT FLEX CONNECTION**  
M4.3 NO SCALE

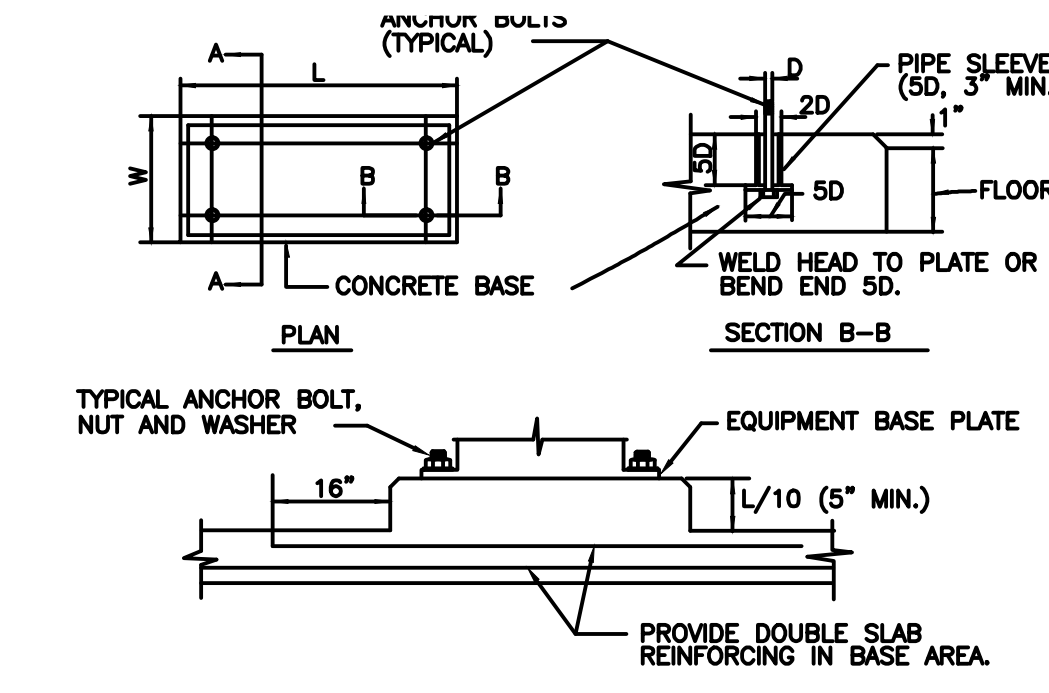


**5 CONCRETE EQUIPMENT BASES**  
M4.3 NO SCALE

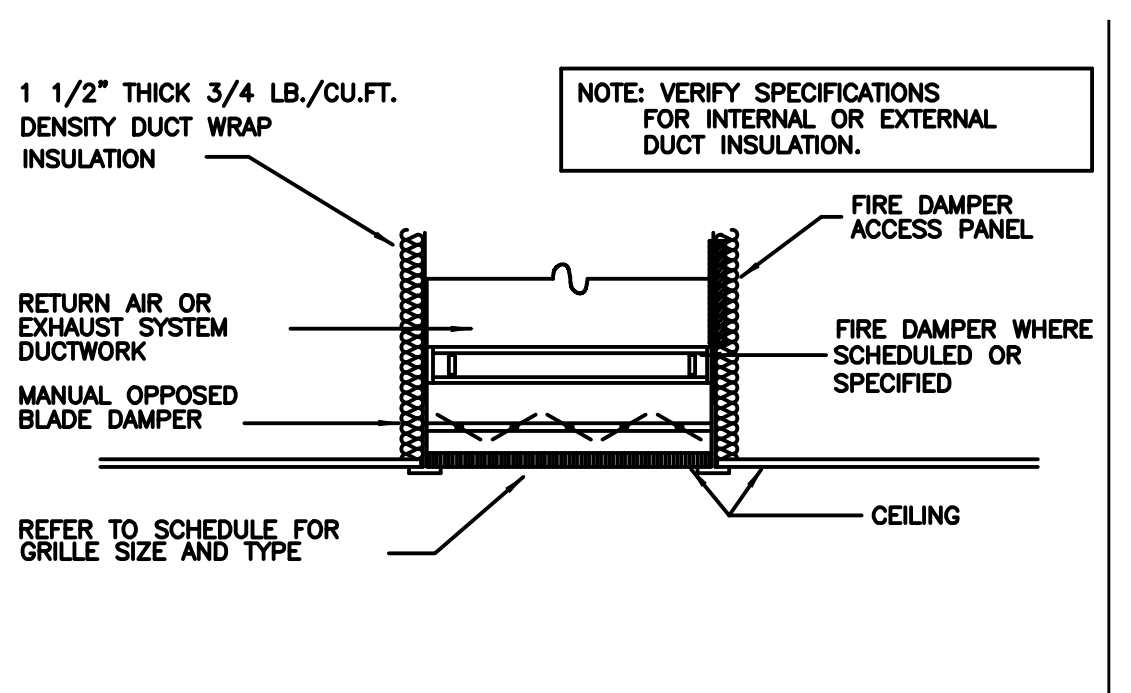


**6 EXHAUST/RETURN GRILLE DETAIL**  
M4.3 NO SCALE

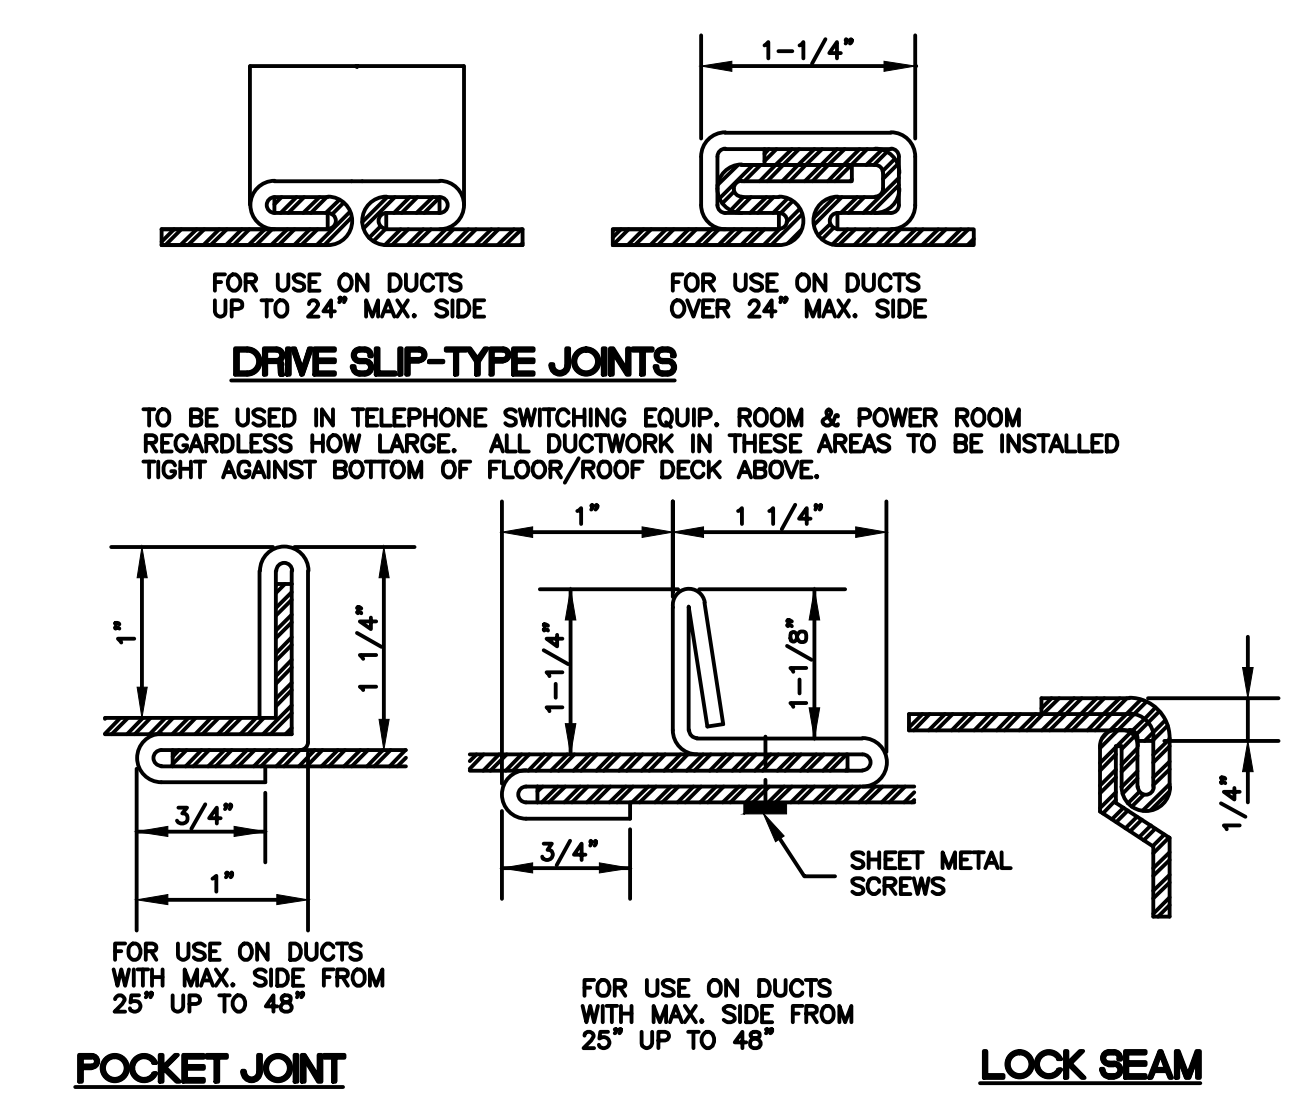


**7 DUCT JOINTS AND SEAMS DETAIL**  
M4.3 NO SCALE

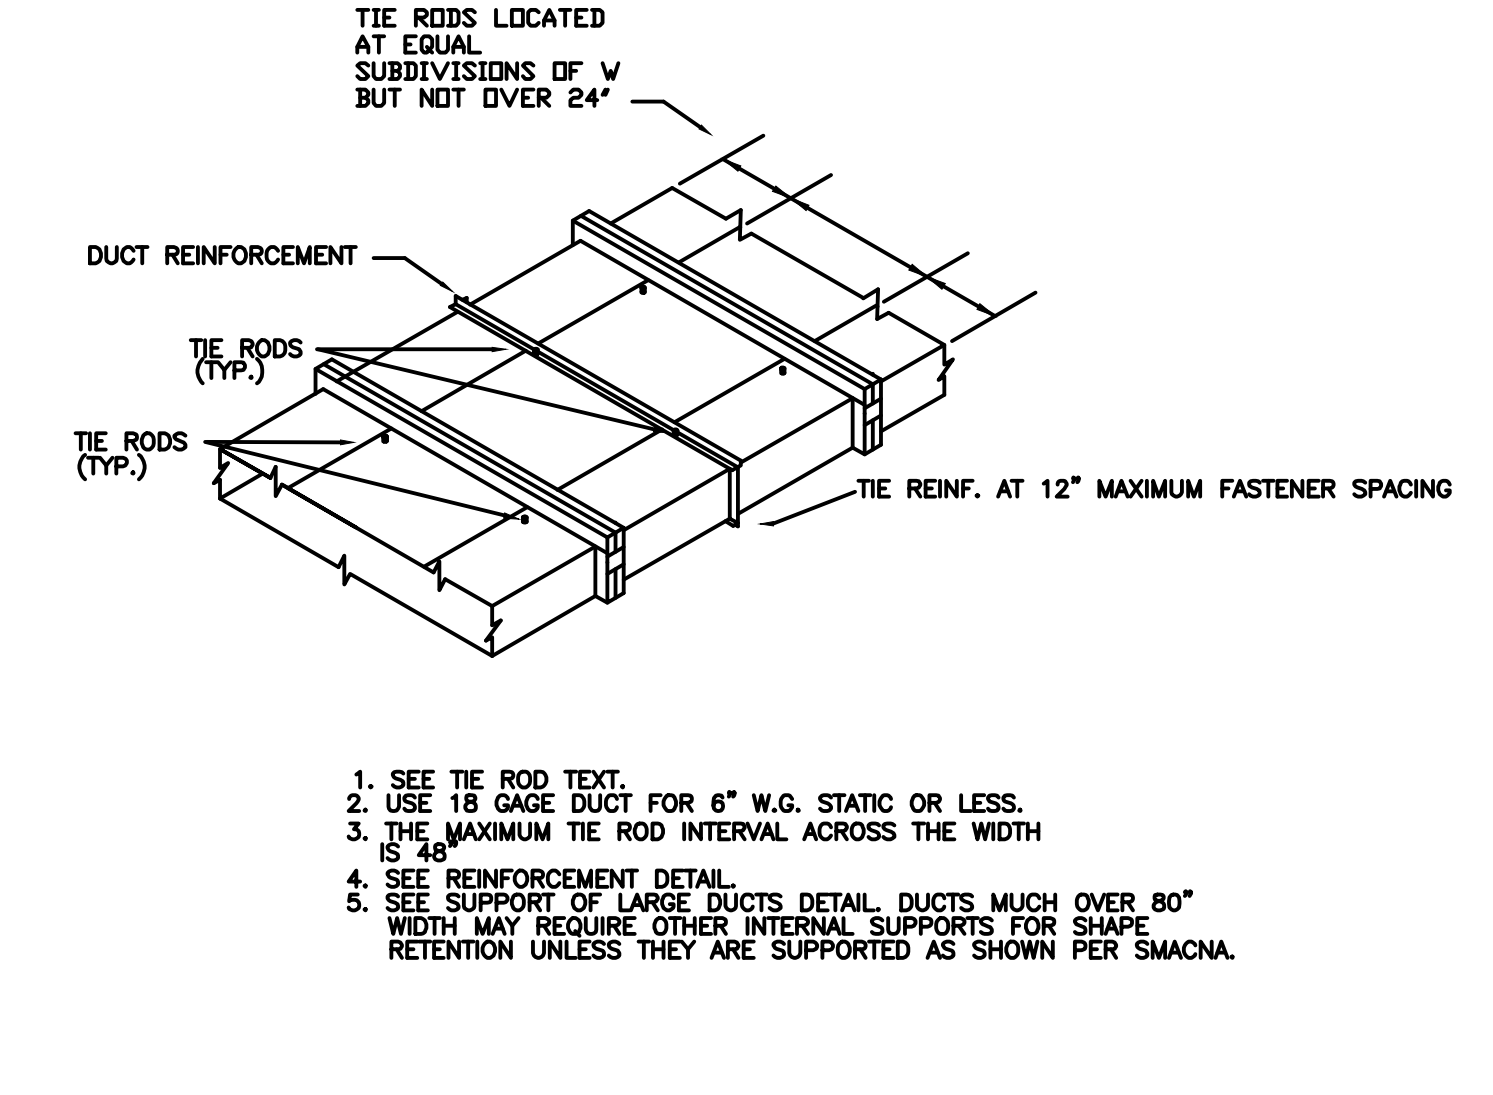


**8 WIDE DUCT TIE ROD - INTERNAL SUPPORT DETAIL**  
(DUCTS GREATER THAN 48" WIDE)  
M4.3 NO SCALE

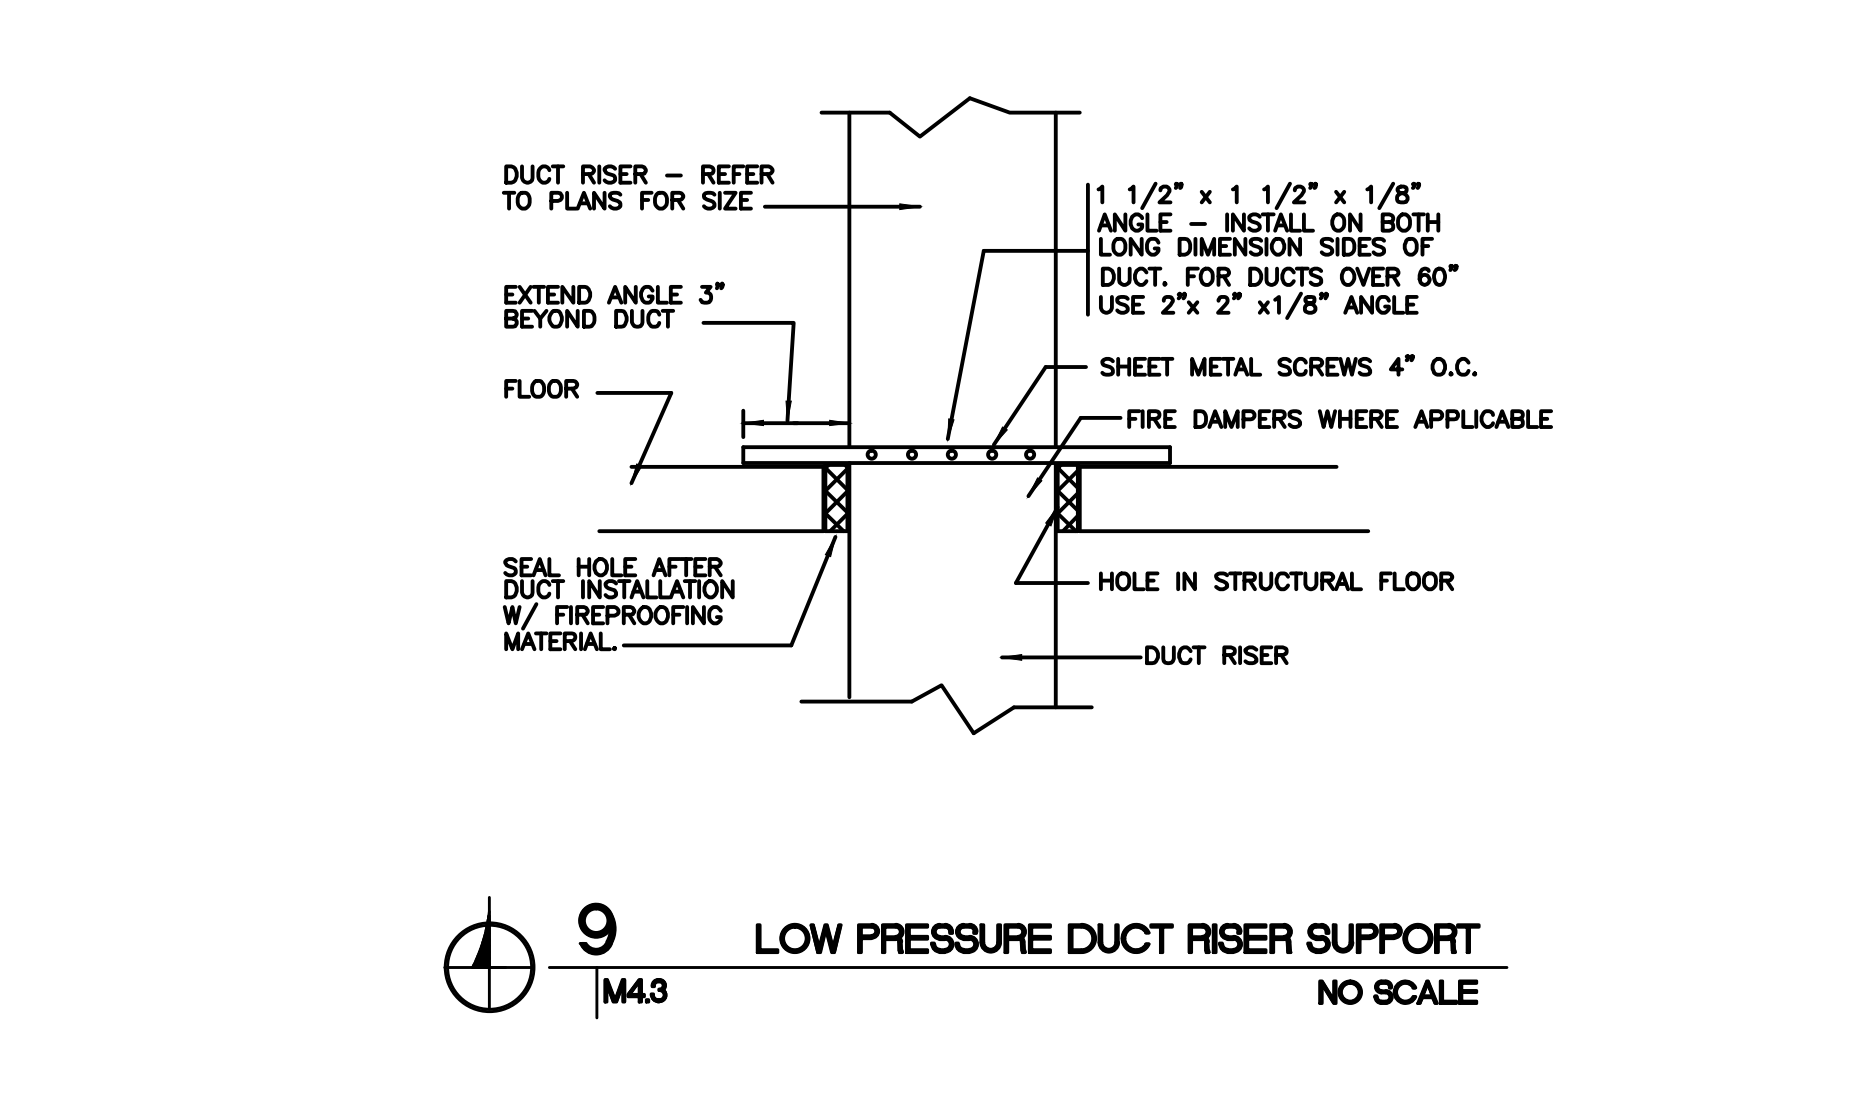


**9 LOW PRESSURE DUCT RISER SUPPORT**  
M4.3 NO SCALE

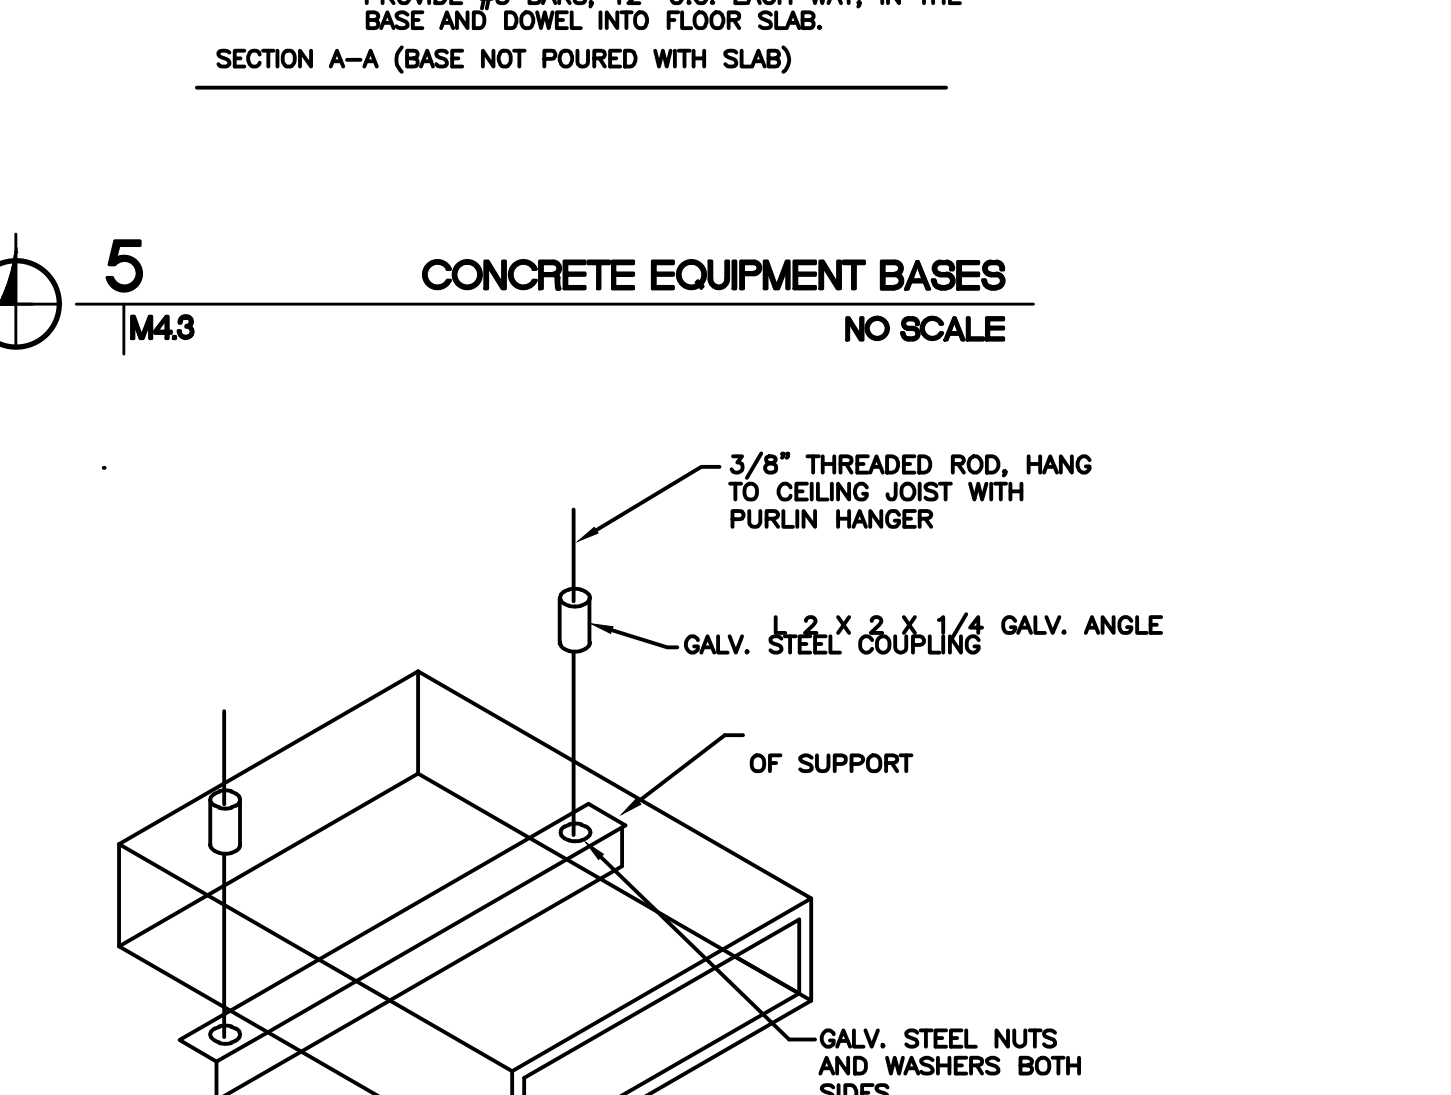


**10 DUCT SUPPORT DETAIL (TRAPEZE HANGER)**  
M4.3 NO SCALE

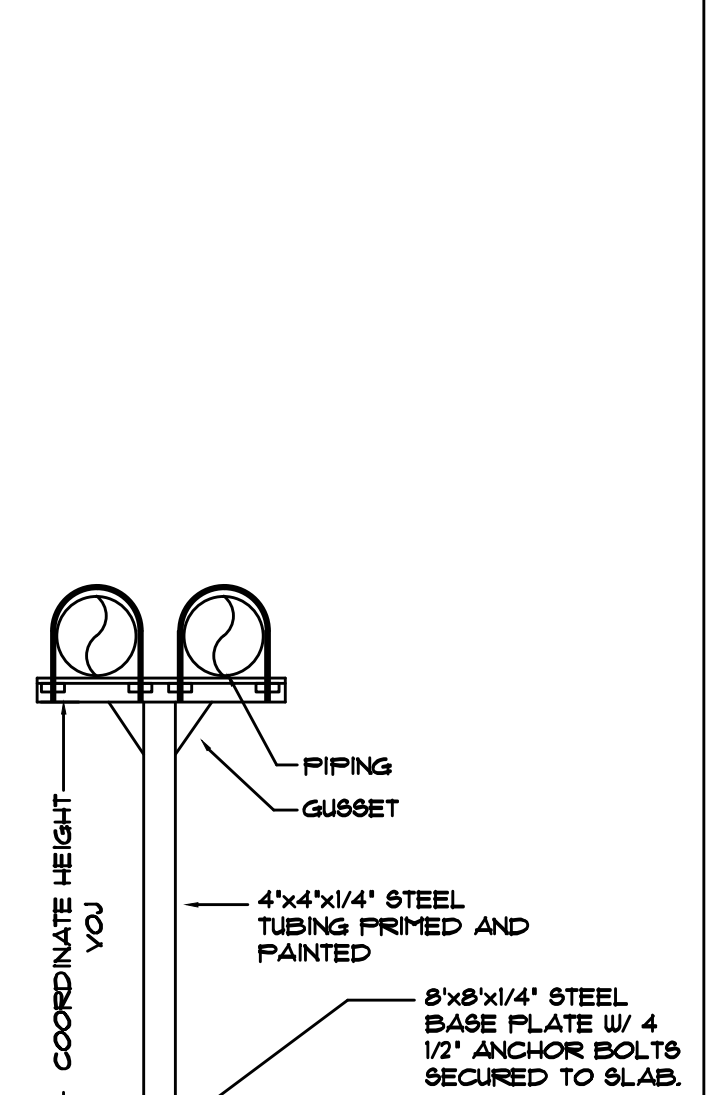


**11 PIPE STAND SUPPORT DETAIL**  
M4.3 NO SCALE

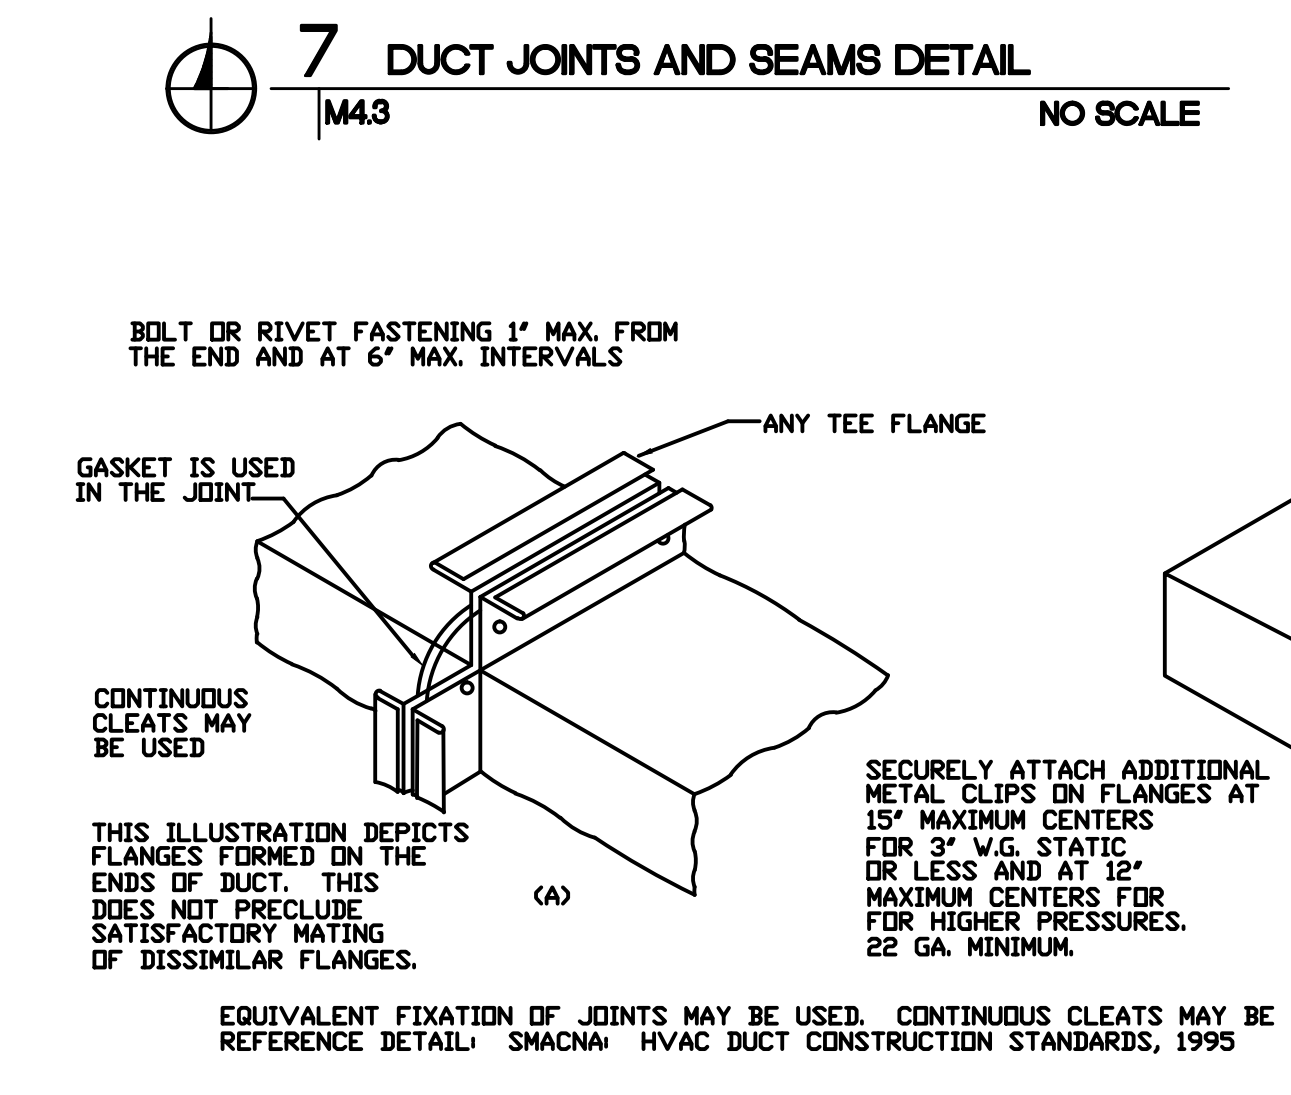


**12 GASKETED DUCT MATE JOINT DETAIL**  
M4.3 NO SCALE

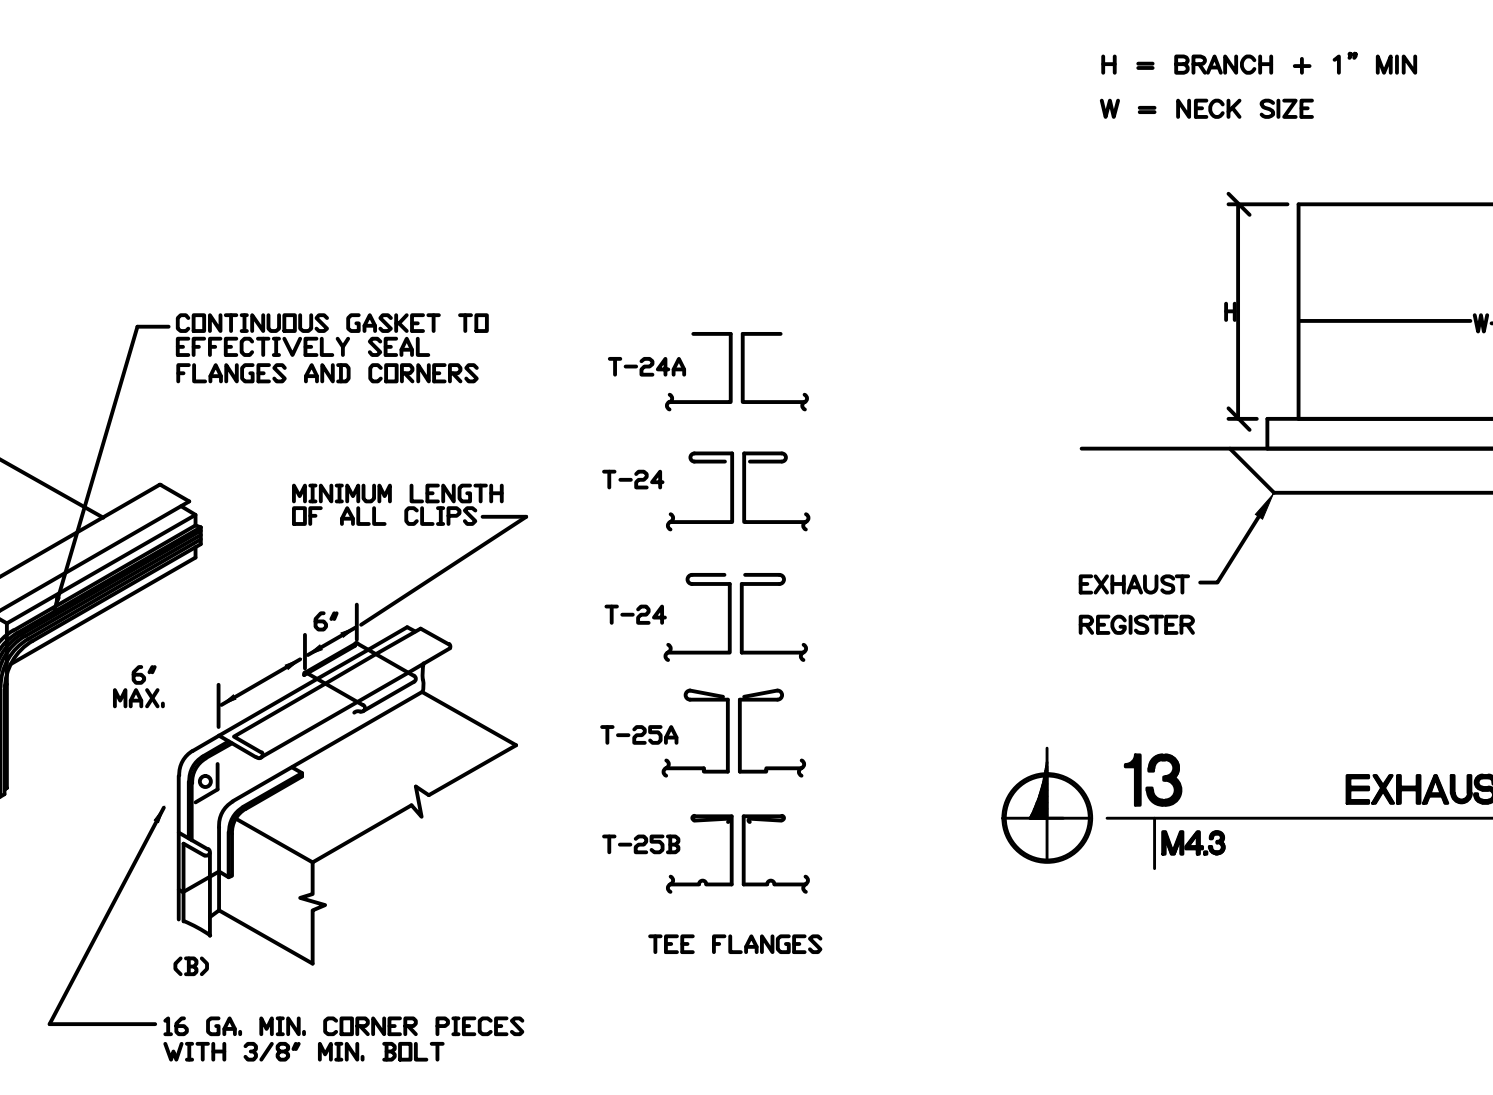


**13 EXHAUST/RETURN REGISTER DETAIL**  
M4.3 NO SCALE

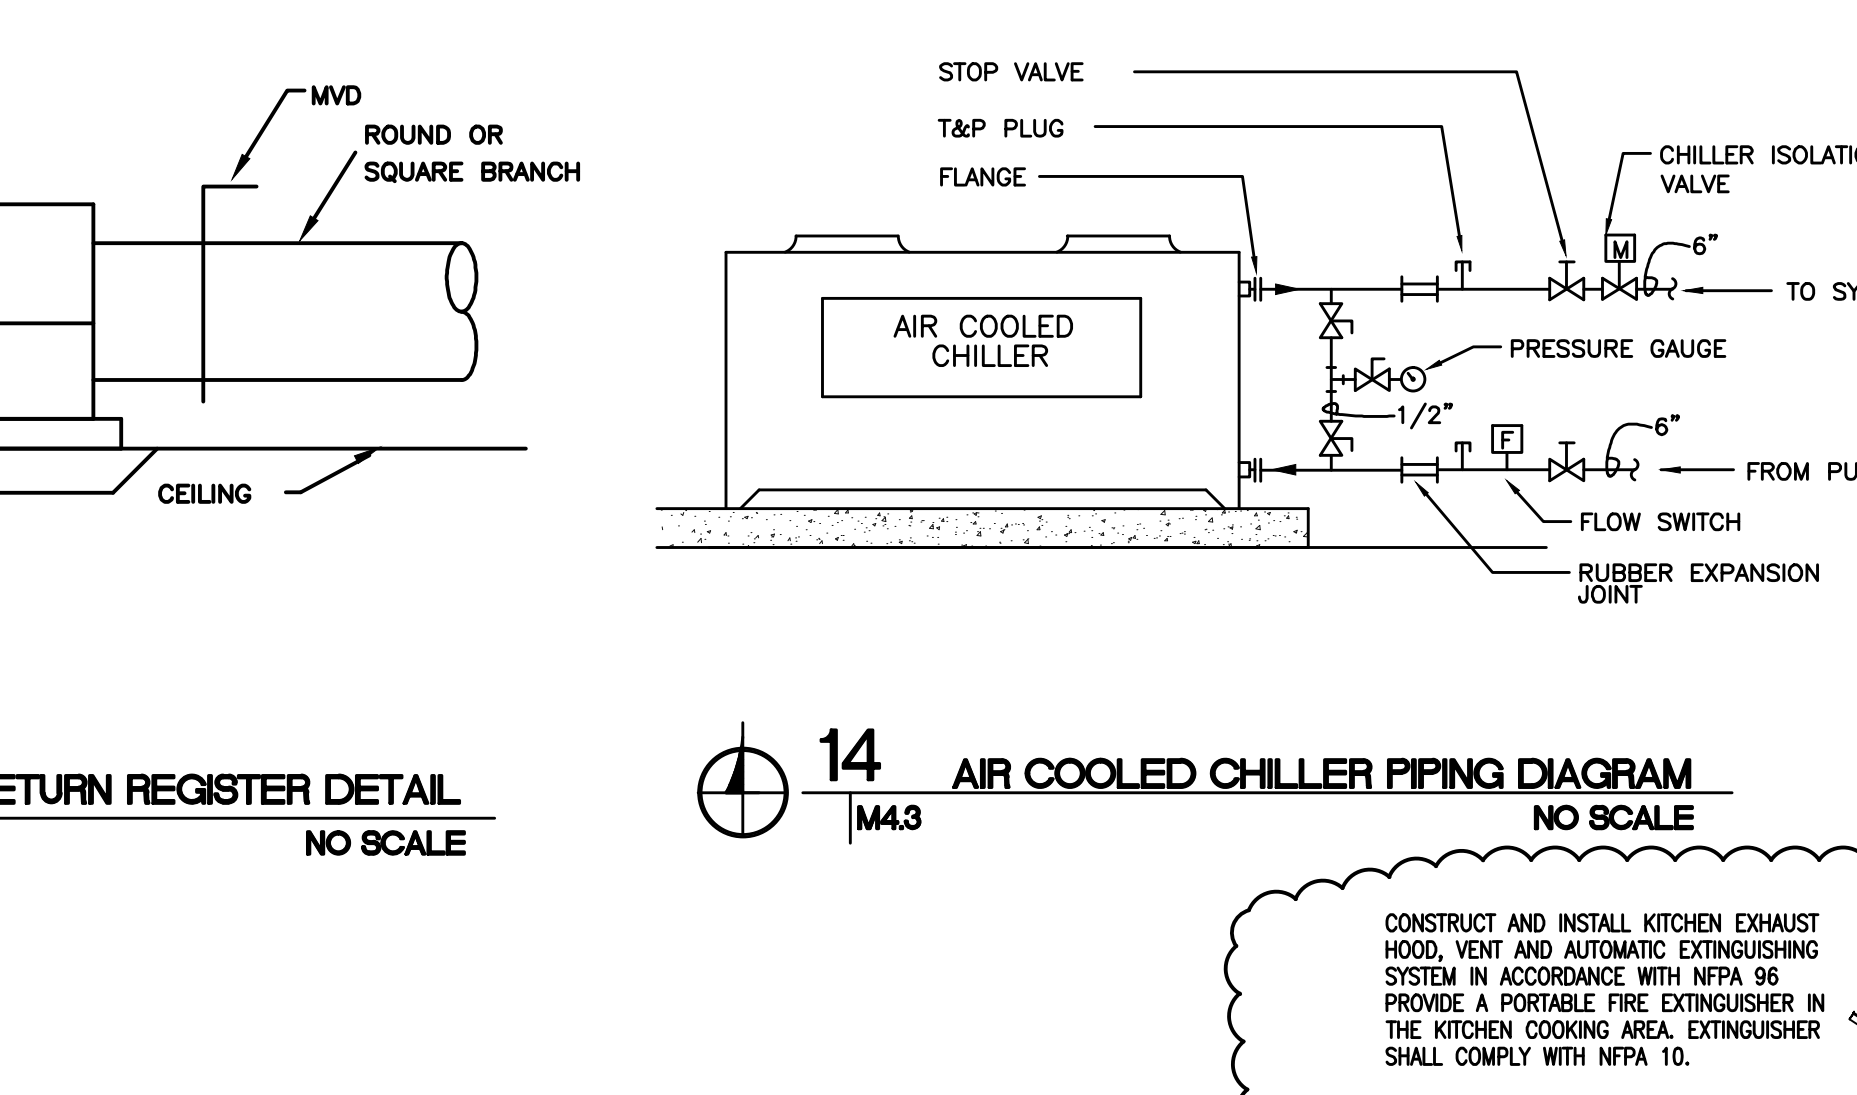


**14 AIR COOLED CHILLER PIPING DIAGRAM**  
M4.3 NO SCALE

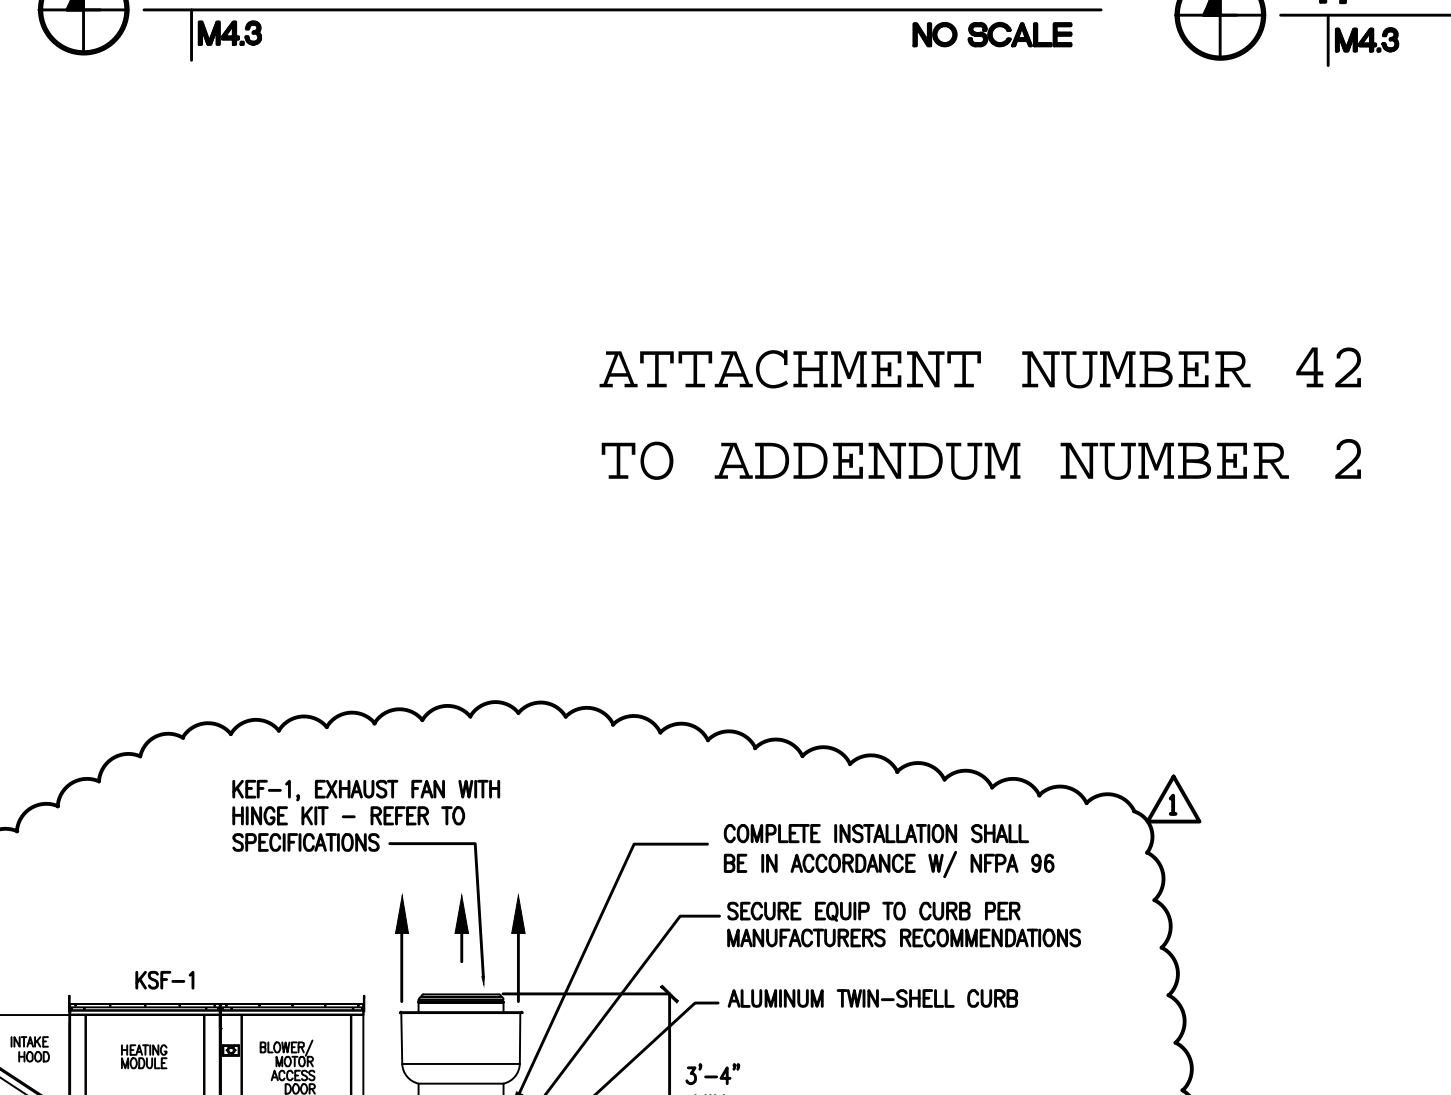

 
**15 WIDE DUCT REINFORCED ON ALL SIDES**  
(DUCTS GREATER THAN 48" WIDE)  
M4.3 NO SCALE



**16 PLASTIC LAMINATE NAMEPLATE DETAIL**  
M4.3 NO SCALE

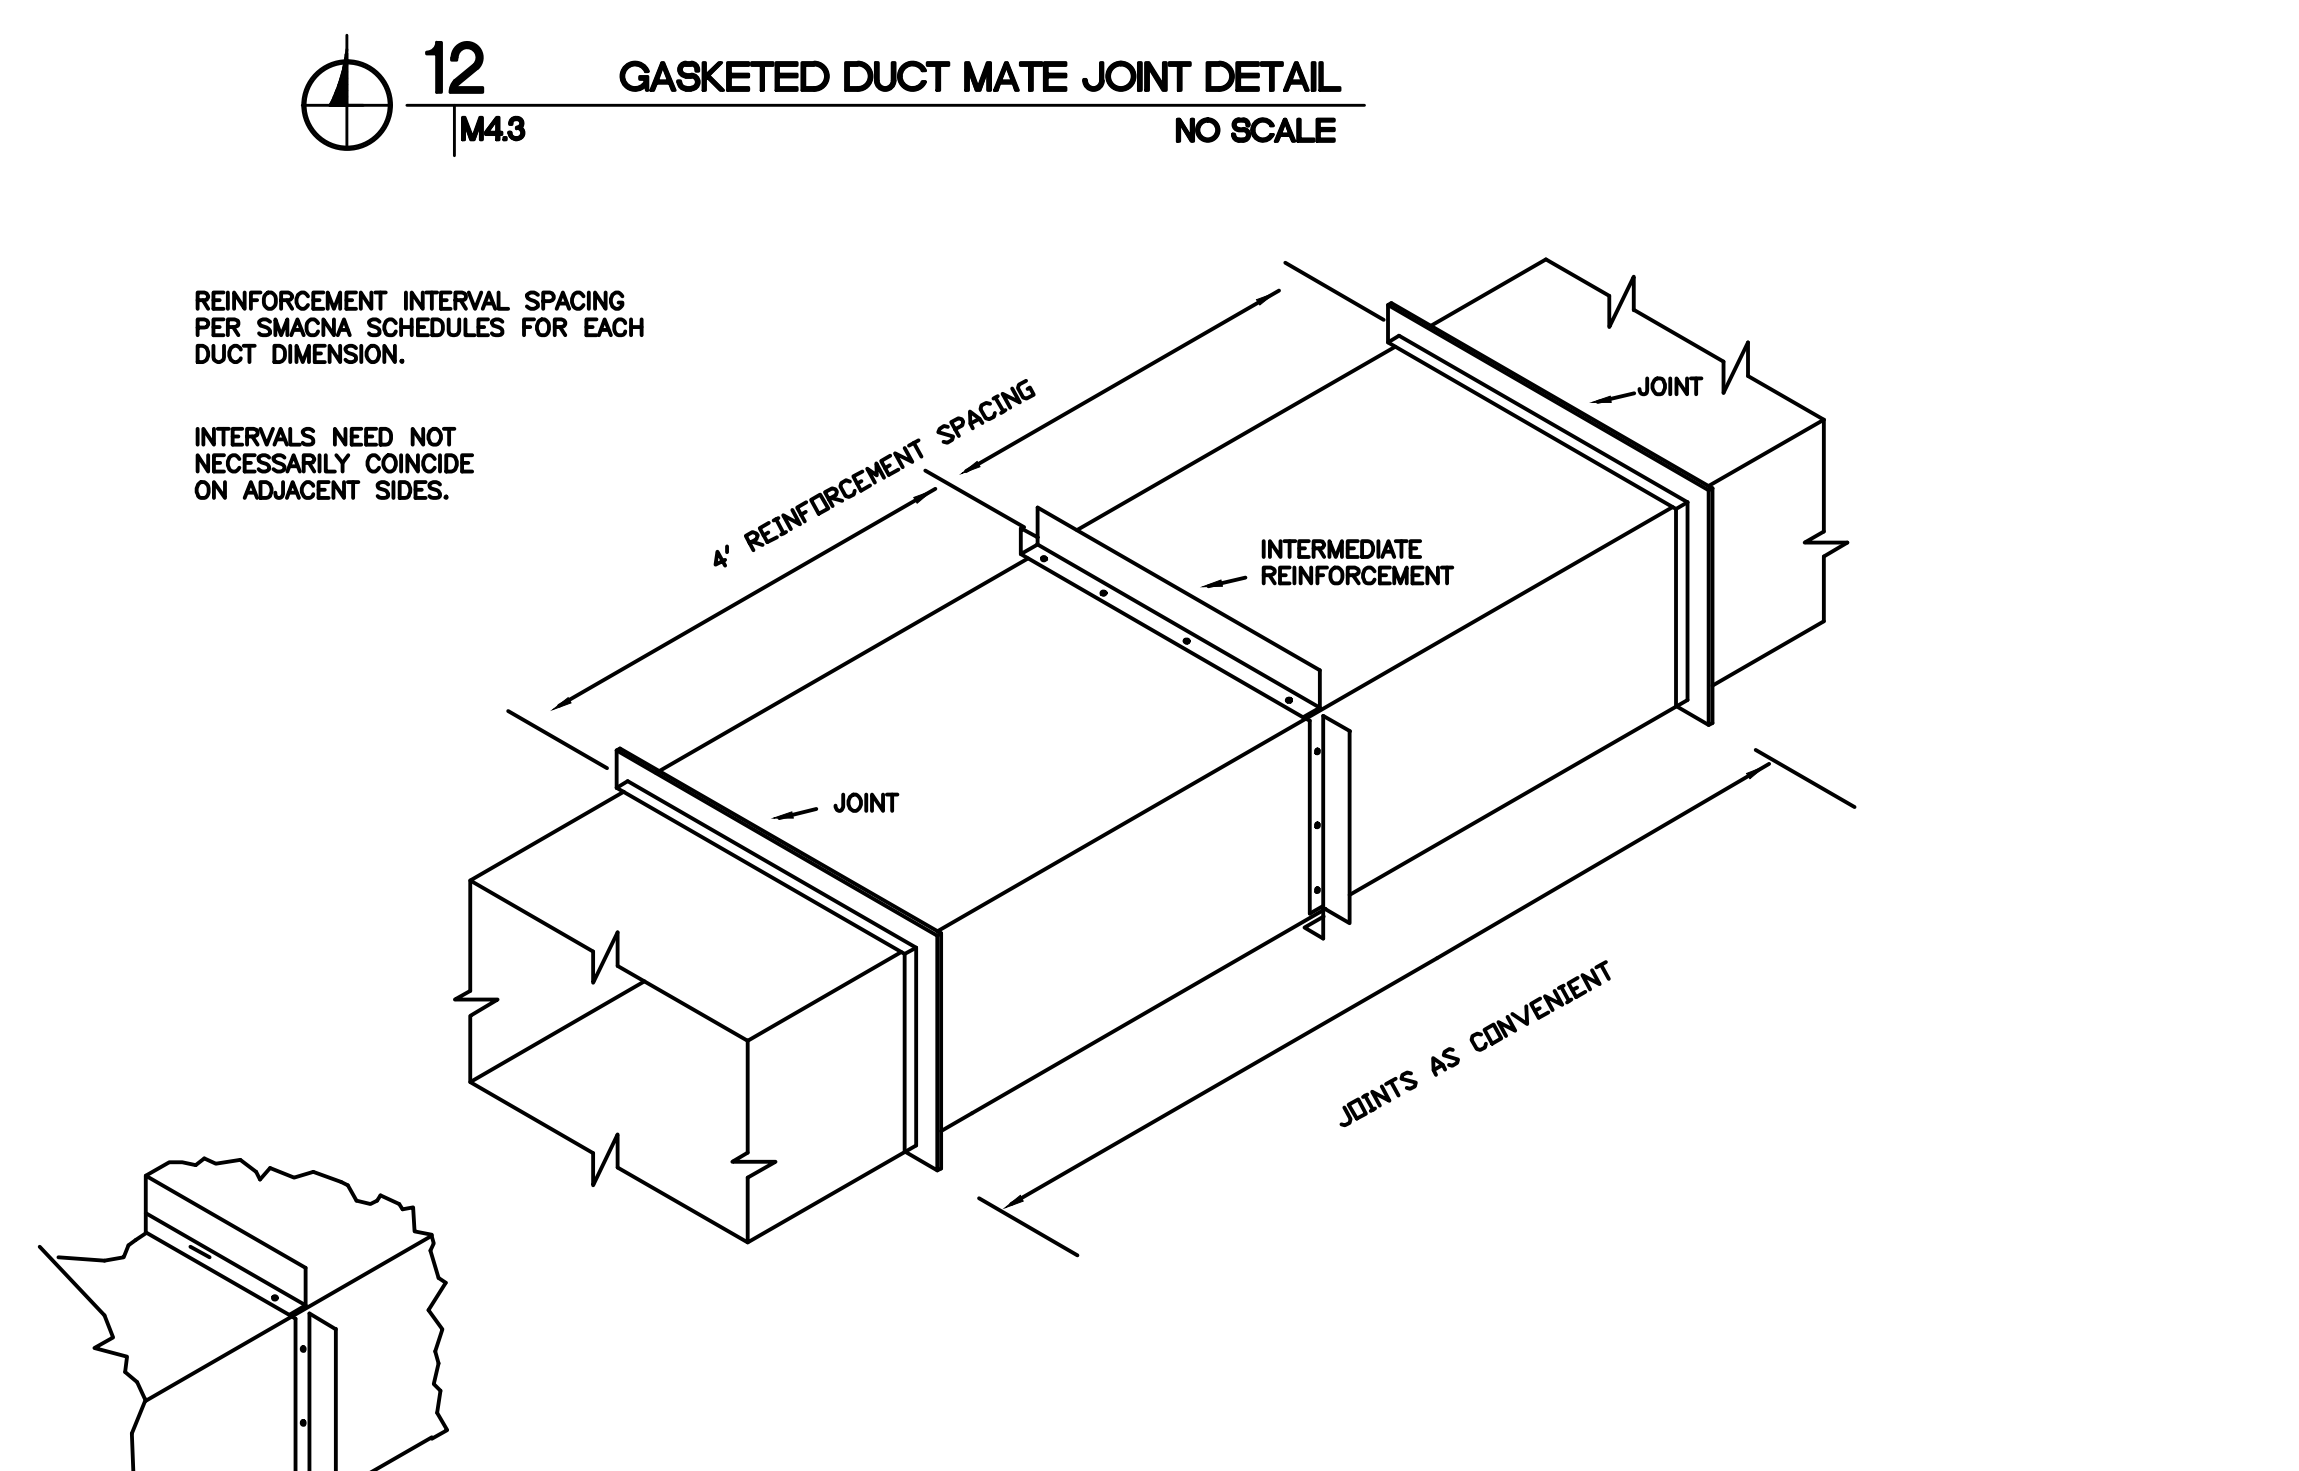

**17 KITCHEN HOOD SECTION**  
M4.1 NO SCALE

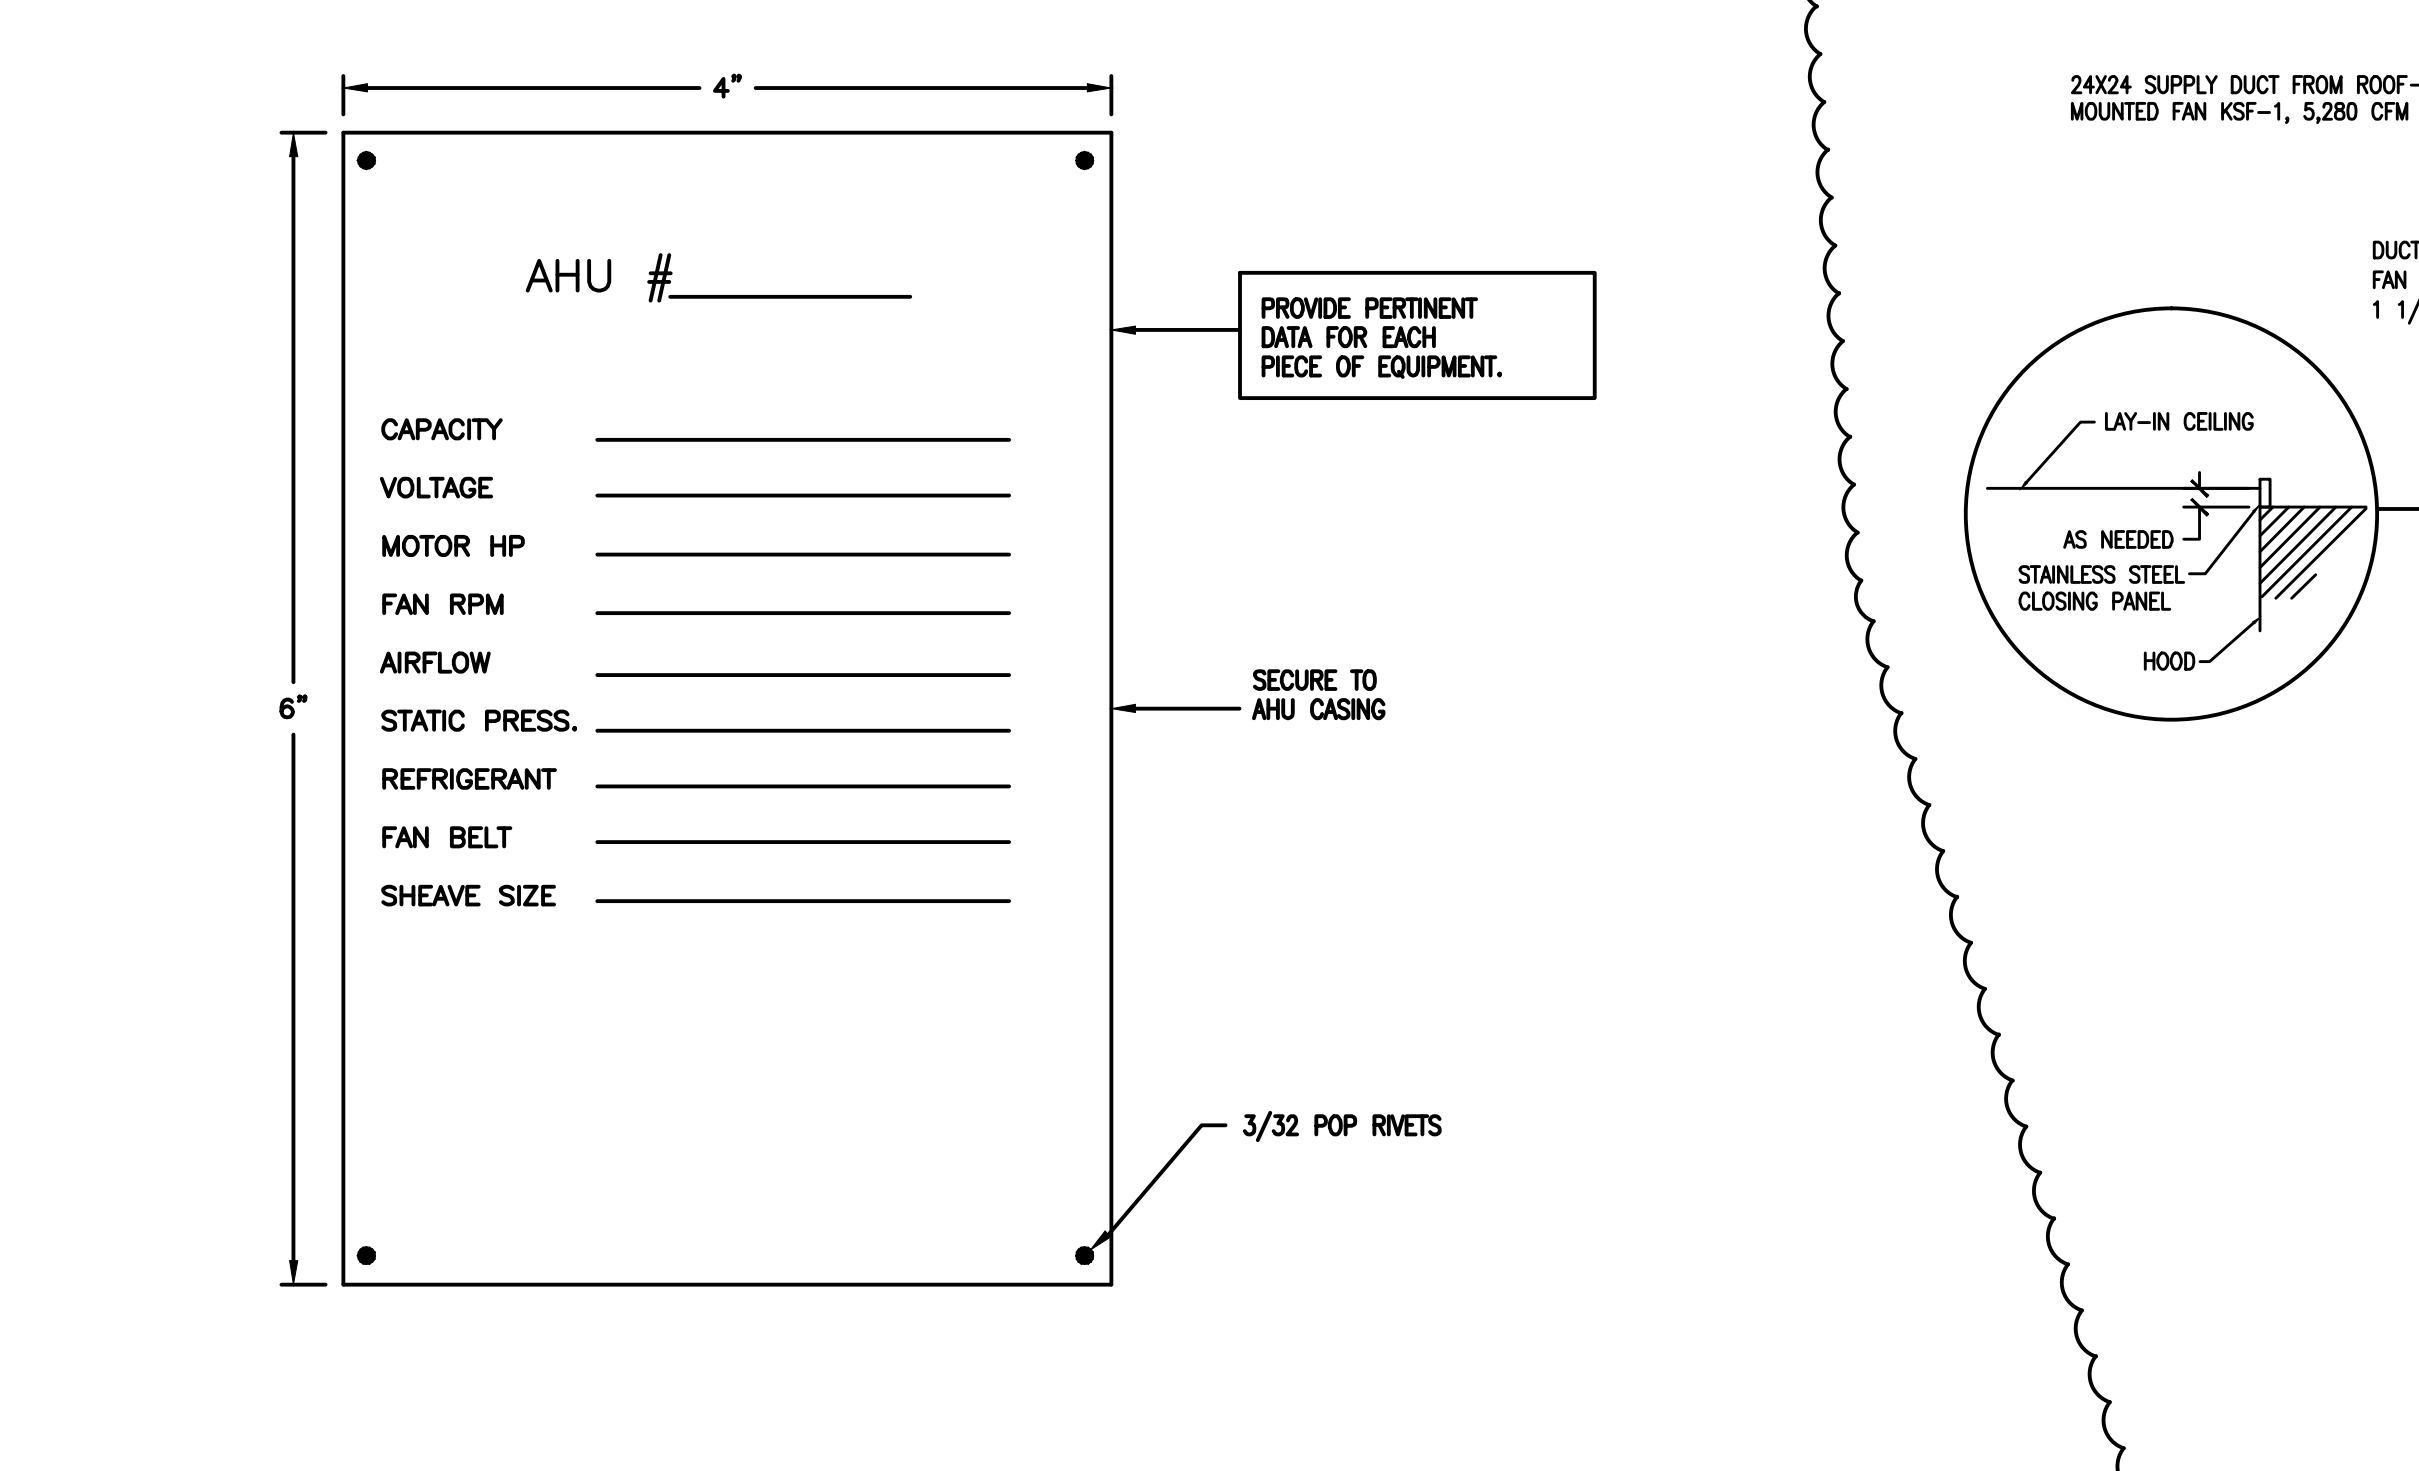

**ATTACHMENT NUMBER 42 TO ADDENDUM NUMBER 2**

NEW PHOENIX PRE-K THROUGH 12 SCHOOL

MECHANICAL DETAILS

DRAWN: ABF  
CHECKED: JSL  
SCALE:  
DATE: 05-24-2010

M4.3

**ASSOCIATED DESIGN GROUP, INC.**  
CONSULTING ENGINEERS

**CORPORATE OFFICE**  
114 Toledo Drive  
Lafayette, Louisiana 70506  
(337) 284-8710

**NEW ORLEANS BRANCH**  
1010 Common St.  
Suite 8405  
New Orleans, LA 70112  
(504) 561-8333

Project # 02193